


RENOVATIONS TO COSMETOLOGY AND ALLIED
HEALTH CLASSROOMS

FRANKLIN COUNTY CAREER AND TECHNOLOGY CENTER


FRANKLIN COUNTY TECHNICAL SCHOOL AUTHORITY
CRA PROJECT No. 2776
4/30/2014

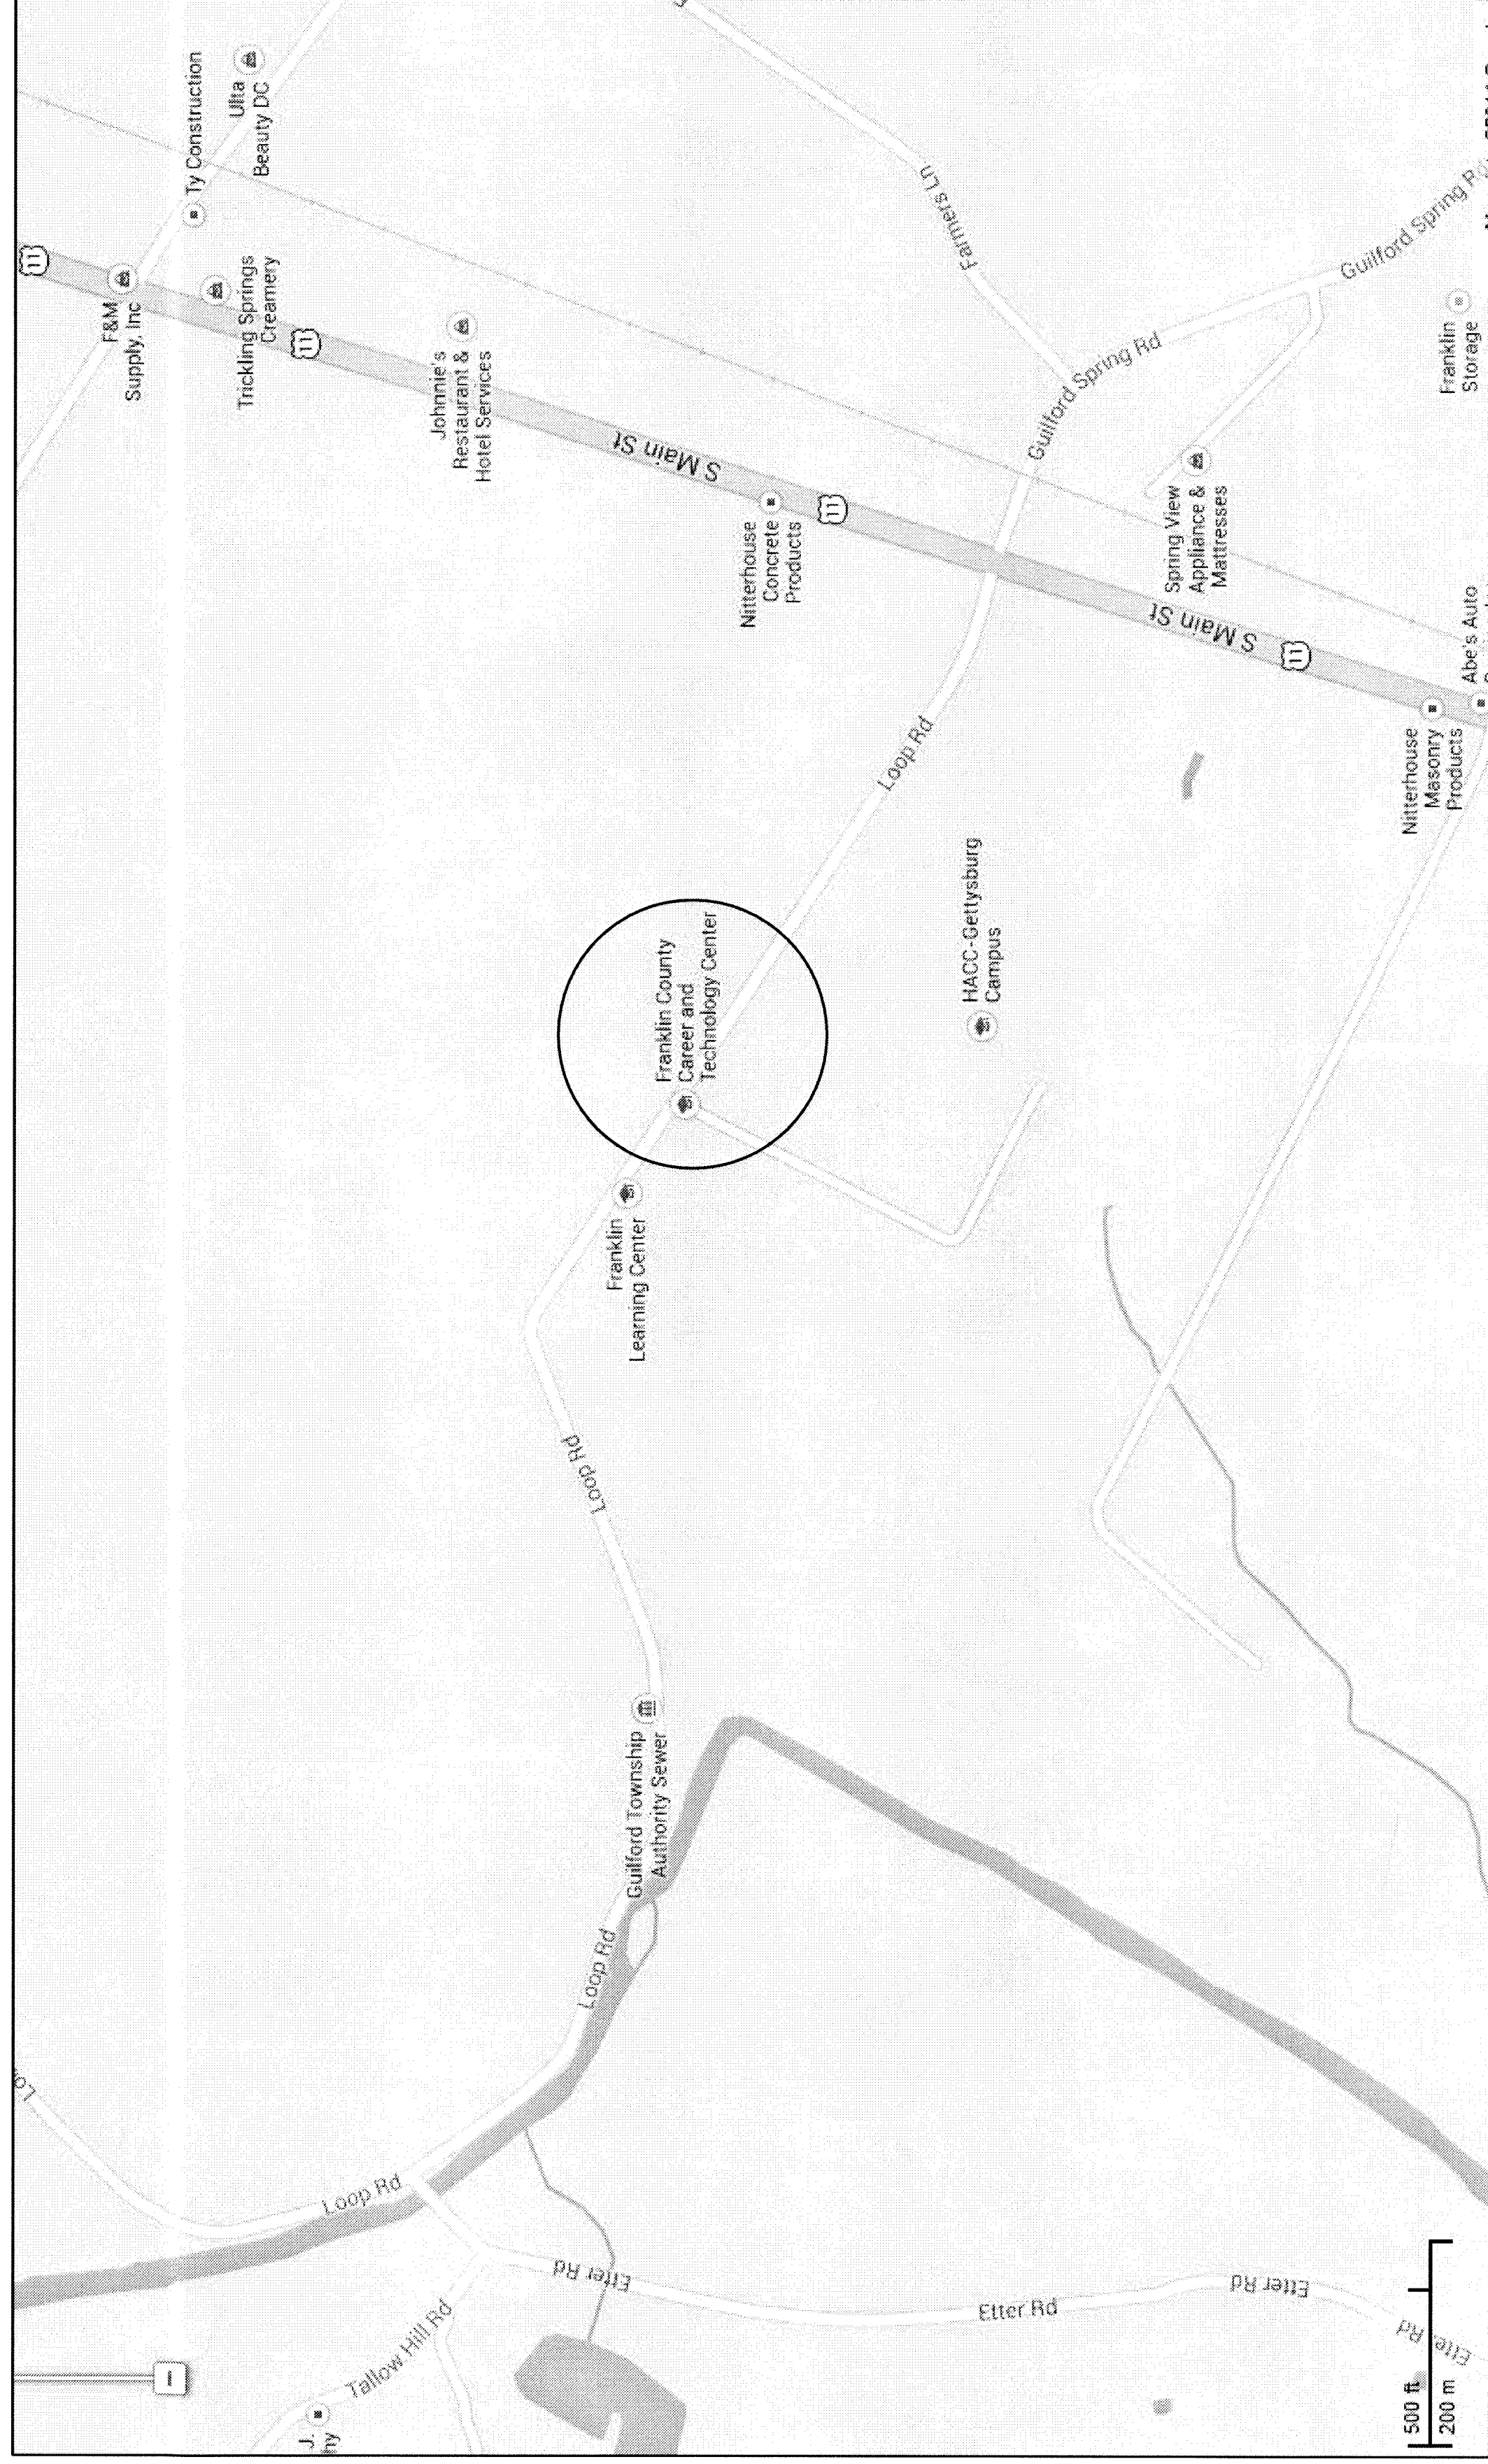

Sheet Number	Sheet Name
GENERAL	
CS.1	COVER SHEET
ARCHITECTURAL	
A1.1	PLAN LAYOUTS
A1.2	REFLECTED CEILING PLANS, ROOM FINISH, AND SIGNAGE SCHEDULE
A1.3	DOOR SCHEDULE, HOLLOW METAL FRAME, STOREFRONT ELEVATIONS, AND DETAILS
INTERIORS	
I4.1	LARGE SCALE LAYOUT ALLIED HEALTH & COSMETOLOGY
MECHANICAL	
M0.1	HVAC - DEMOLITION & NEW WORK FLOOR PLANS
M0.2	HVAC - DEMOLITION & NEW WORK FLOOR PLANS
M1.1	HVAC - DEMOLITION & NEW WORK FLOOR PLANS
M2.1	HVAC - DEMOLITION & NEW WORK FLOOR PLANS
PLUMBING	
P1.1	PLUMBING - DEMOLITION FLOOR PLANS
P2.1	PLUMBING - NEW YORK FLOOR PLANS
ELECTRICAL	
EE.1	ELECTRICAL LEGEND, ABBREVIATIONS & GENERAL NOTES
ET.1	ELECTRICAL - FLOOR PLANS - DEMOLITION
ET.2	ELECTRICAL - FLOOR PLANS - DEMOLITION
EZ.1	ELECTRICAL FLOOR PLANS
ES.1	ELECTRICAL DETAILS

CRABTREE, ROHRBAUGH & ASSOCIATES - ARCHITECTS

401 EAST WINDING HILL ROAD
MECHANICSBURG, PENNSYLVANIA 17055
Phone: (717) 458-0272
Fax: (717) 458-0047
www.cra-architects.com

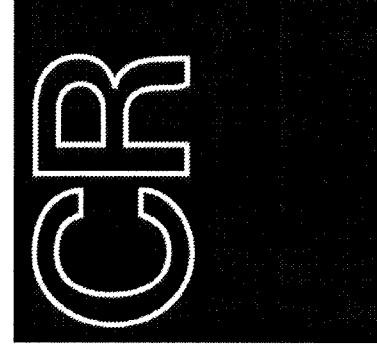

M.E.P. ENGINEER
PYRAMID ENGINEERING, P.C.
300 5th Avenue
Altoona, PA 16601
Phone: 814-946-9910