

 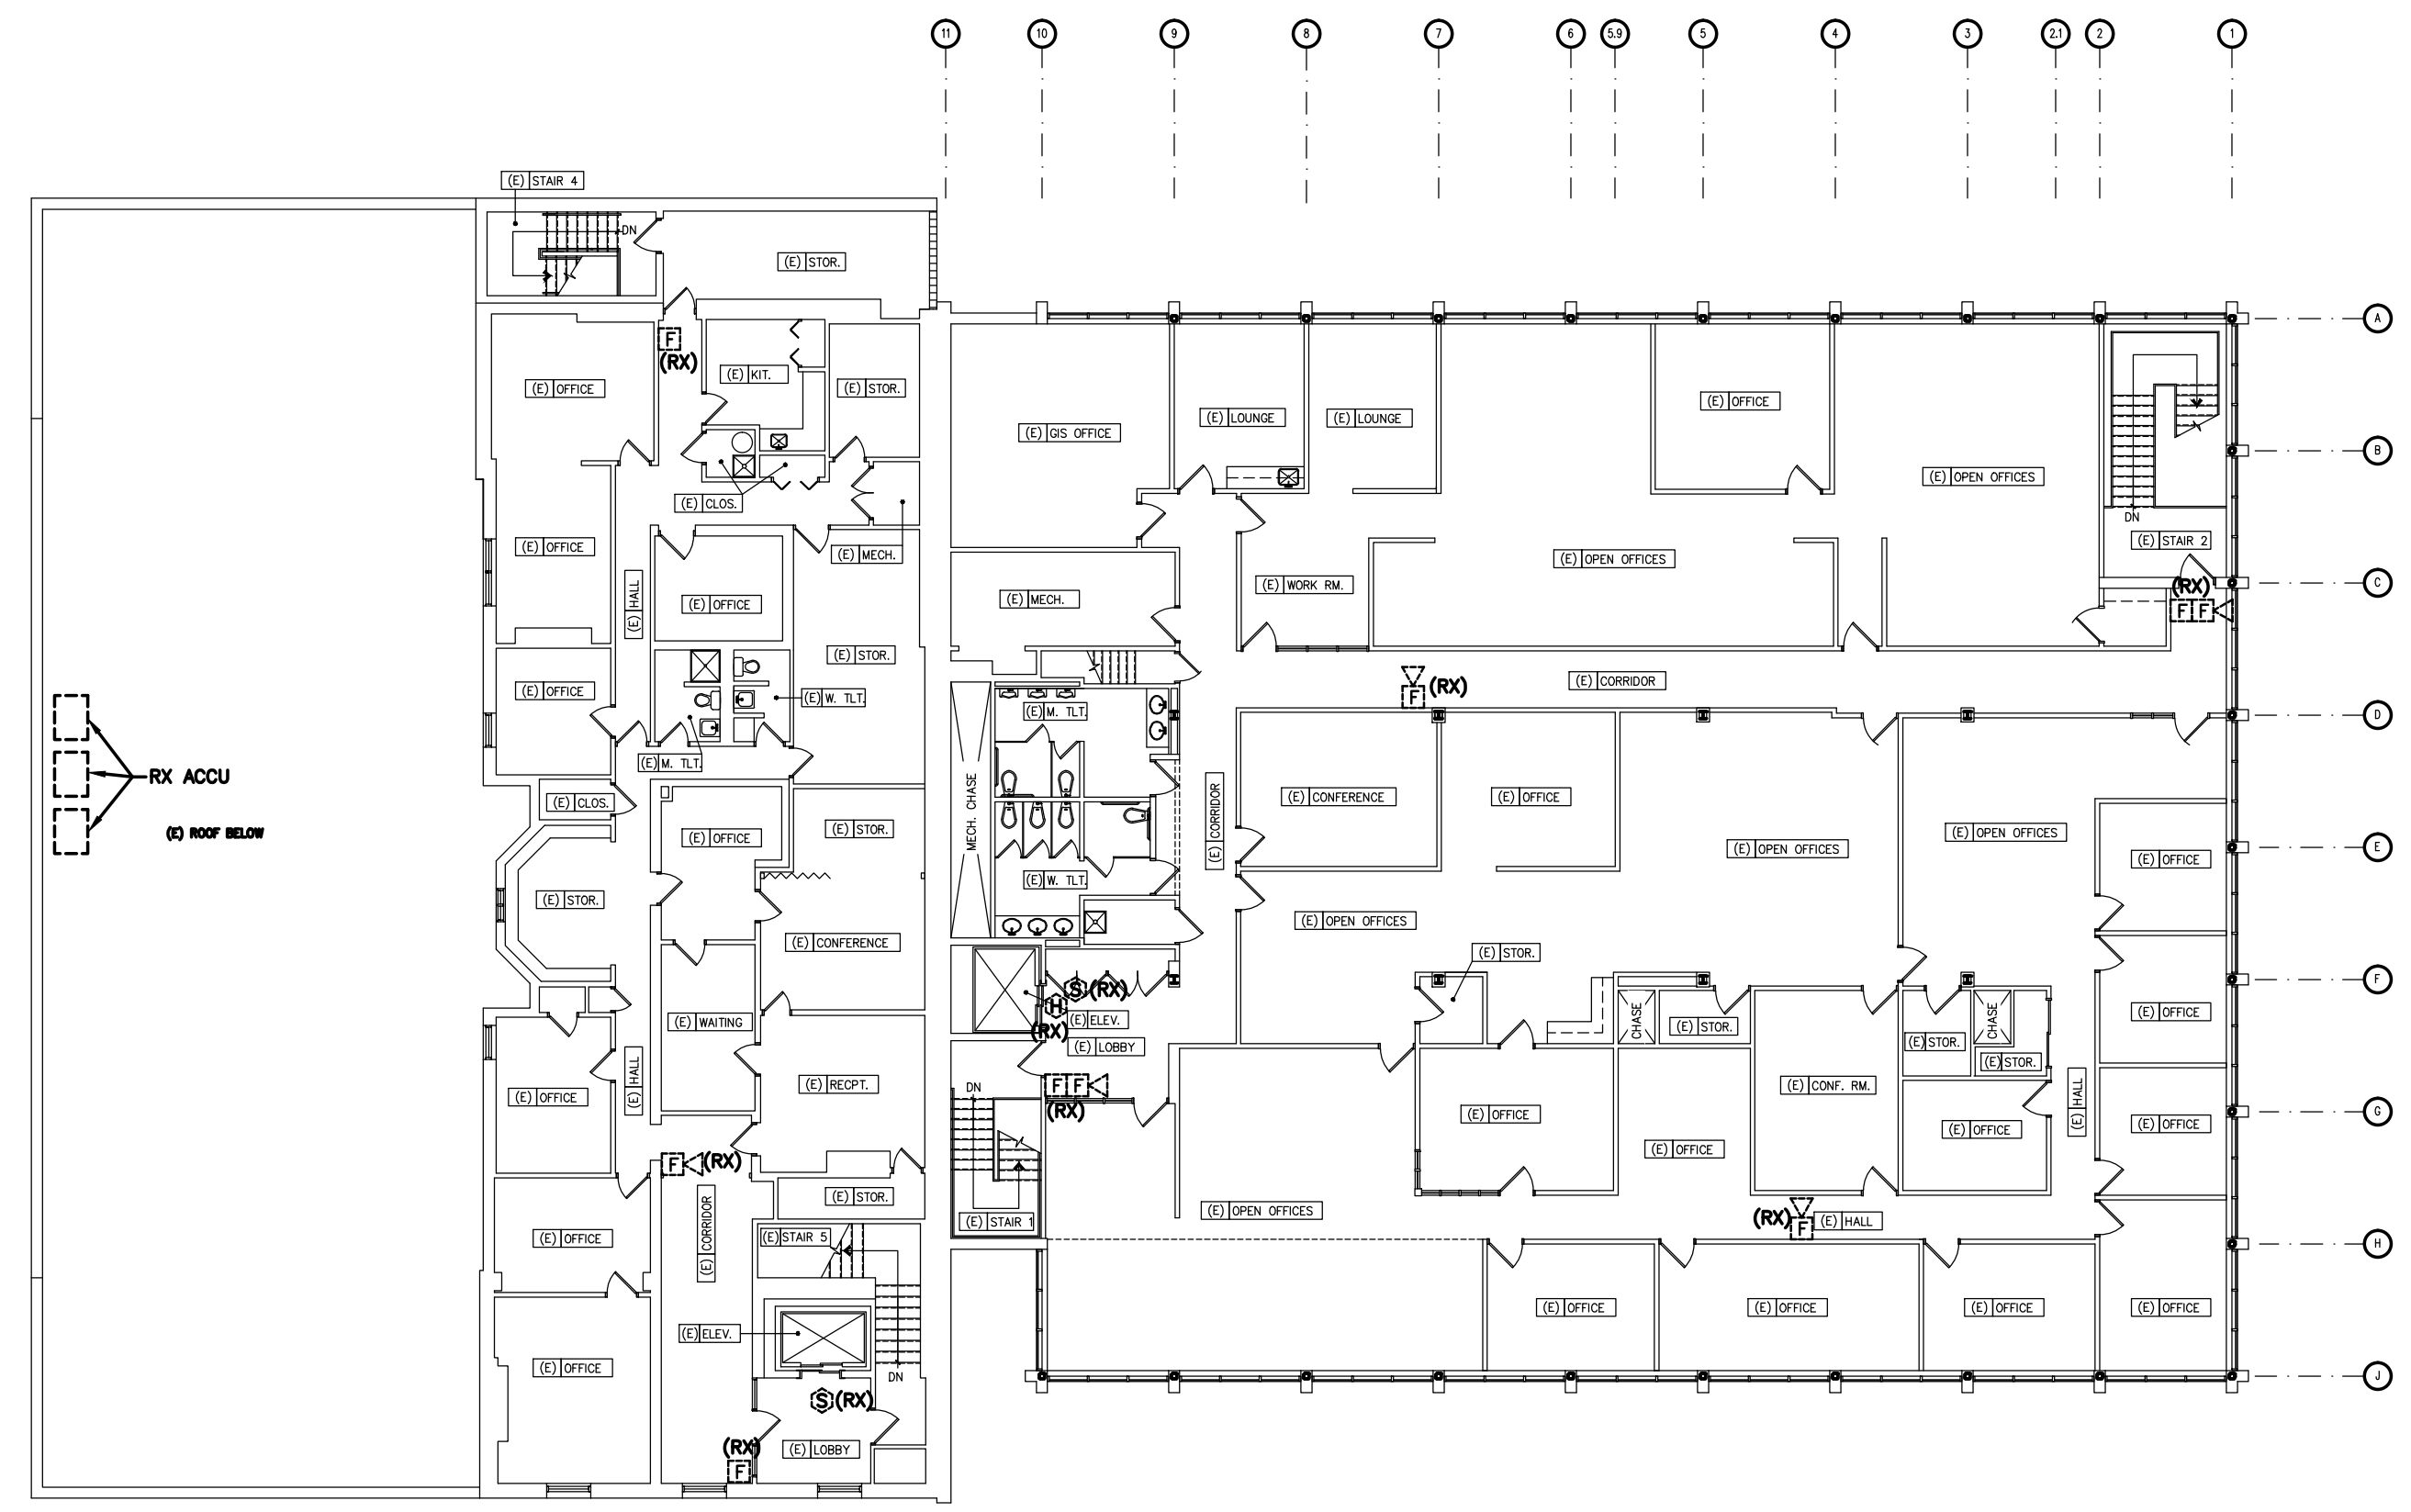


SECOND FLOOR PLAN - ELECTRICAL DEMO
SCALE: 1/16" = 1'-0"

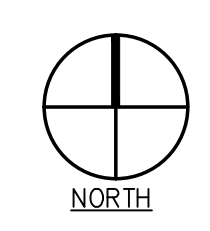


THIRD FLOOR PLAN - ELECTRICAL DEMO
SCALE: 1/16" = 1'-0"



RHL ENGINEERING COMPANY, INC.
3 West Second Street
Frederick, Md. 21701
OFFICE: (301) 695-9424
FAX: (301) 293-6338
E-mail: rhlengr@rhlengr.com

Professional Certification. I hereby certify that these documents were prepared or approved by me, and that I am a duly licensed professional engineer under the laws of the State of Maryland. License No: 45511 Expiration Date: 06/03/2018

BUSHEY FEIGHT MORIN ARCHITECTS INC.
473 North Potomac Street, Hagerstown, Md 21740
301-733-5600 Fax 301-733-5612
E-mail: BFM@BFMArchitects.com
copyright 2014, Bushey Feight Morin Architects, Inc.

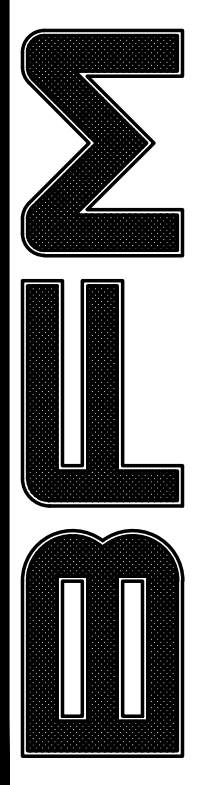

BFM No. 14028 WASH. CO. ADMINISTRATION COMPLEX
RHL No. 13208 FIRST FLOOR RENOVATIONS

BID DOCUMENTS

SECOND & THIRD FLOOR PLANS ELECTRICAL DEMO

E0.3

3 OF 14 SHEETS

DATE : 08.15.14