 




RHL ENGINEERING COMPANY, INC.
 3 West Second Street
 Frederick, Md. 21701
 OFFICE: (301) 695-9424
 FAX: (301) 293-6338
 E-mail: rhlengr@rhlengr.com


Professional Certification. I hereby certify that these documents were prepared or approved by me, and that I am a duly licensed professional engineer under the laws of the State of Maryland. License No: 45511 Expiration Date: 06/03/2018



BUSHEY FEIGHT MORIN ARCHITECTS INC.
 473 North Potomac Street, Hagerstown, Md 21740
 301-733-5600 Fax 301-733-5612
 E-mail: BFM@BFMArchitects.com

BFM
 BUSHEY FEIGHT MORIN ARCHITECTS, INC.
 WASH. CO. ADMINISTRATION COMPLEX
 RHL No. 13208 FIRST FLOOR RENOVATIONS

BID DOCUMENTS
 FIRST FLOOR PLAN
 GENERAL POWER
 NEW
E1.2
 5 OF 14 SHEETS
 DATE : 08.15.14

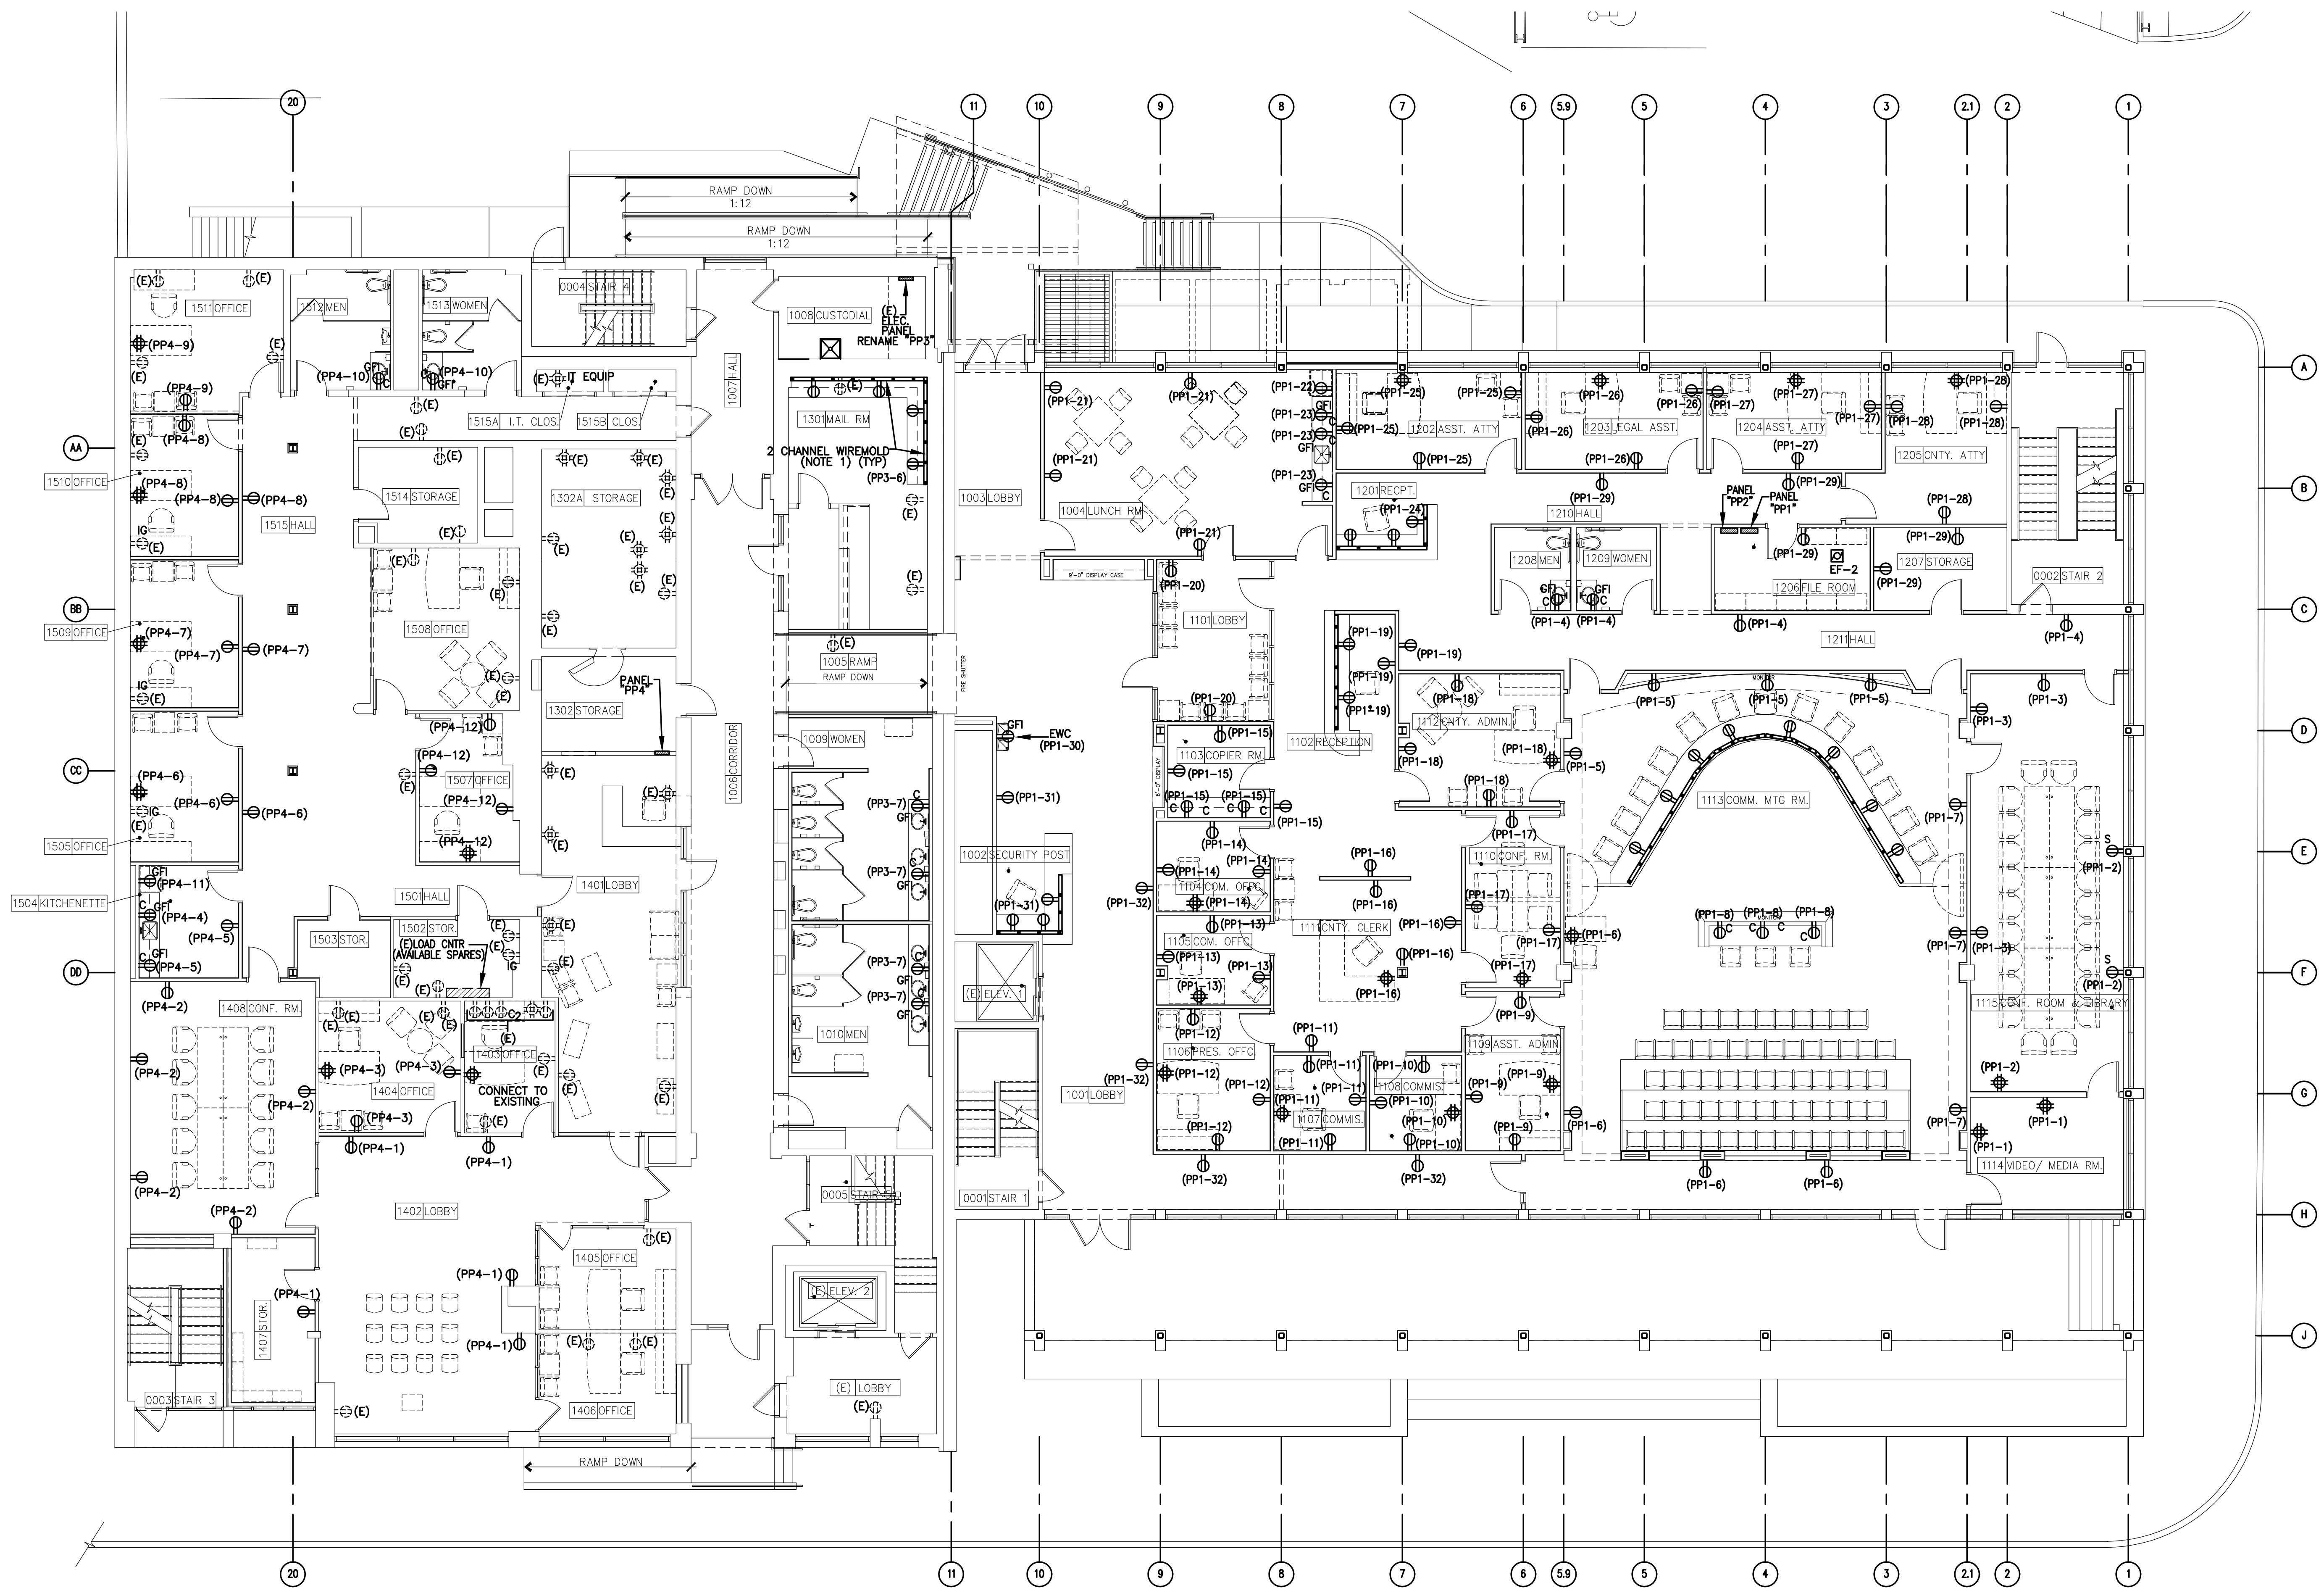

SHEET NOTES:

- FURNISH AND INSTALL 2 CHANNEL WIREMOLD UNDER COUNTER. INSTALL RECEPTACLES AS SHOWN.
- REFER TO "TELECOMMUNICATION" DRAWINGS FOR A/V, DATA AND SECURITY. CONTRACTOR SHALL COORDINATE ADDITIONAL JUNCTION BOXES AND CONDUITS FOR A/V, DATA, AND SECURITY WITH THE "TELECOMMUNICATION" DRAWINGS.

FIRST FLOOR PLAN - GENERAL POWER - NEW
 SCALE: 1/8" = 1'-0"

