






RHL ENGINEERING COMPANY, INC.
 3 West Second Street
 Frederick, Md. 21701
 OFFICE: (301) 695-9424
 FAX: (301) 293-6338
 E-mail: rhlengr@rhlengr.com


Professional Certification. I hereby certify that these documents were prepared or approved by me, and that I am a duly licensed professional engineer under the laws of the State of Maryland. License No: 45511
 Expiration Date: 06/03/2016

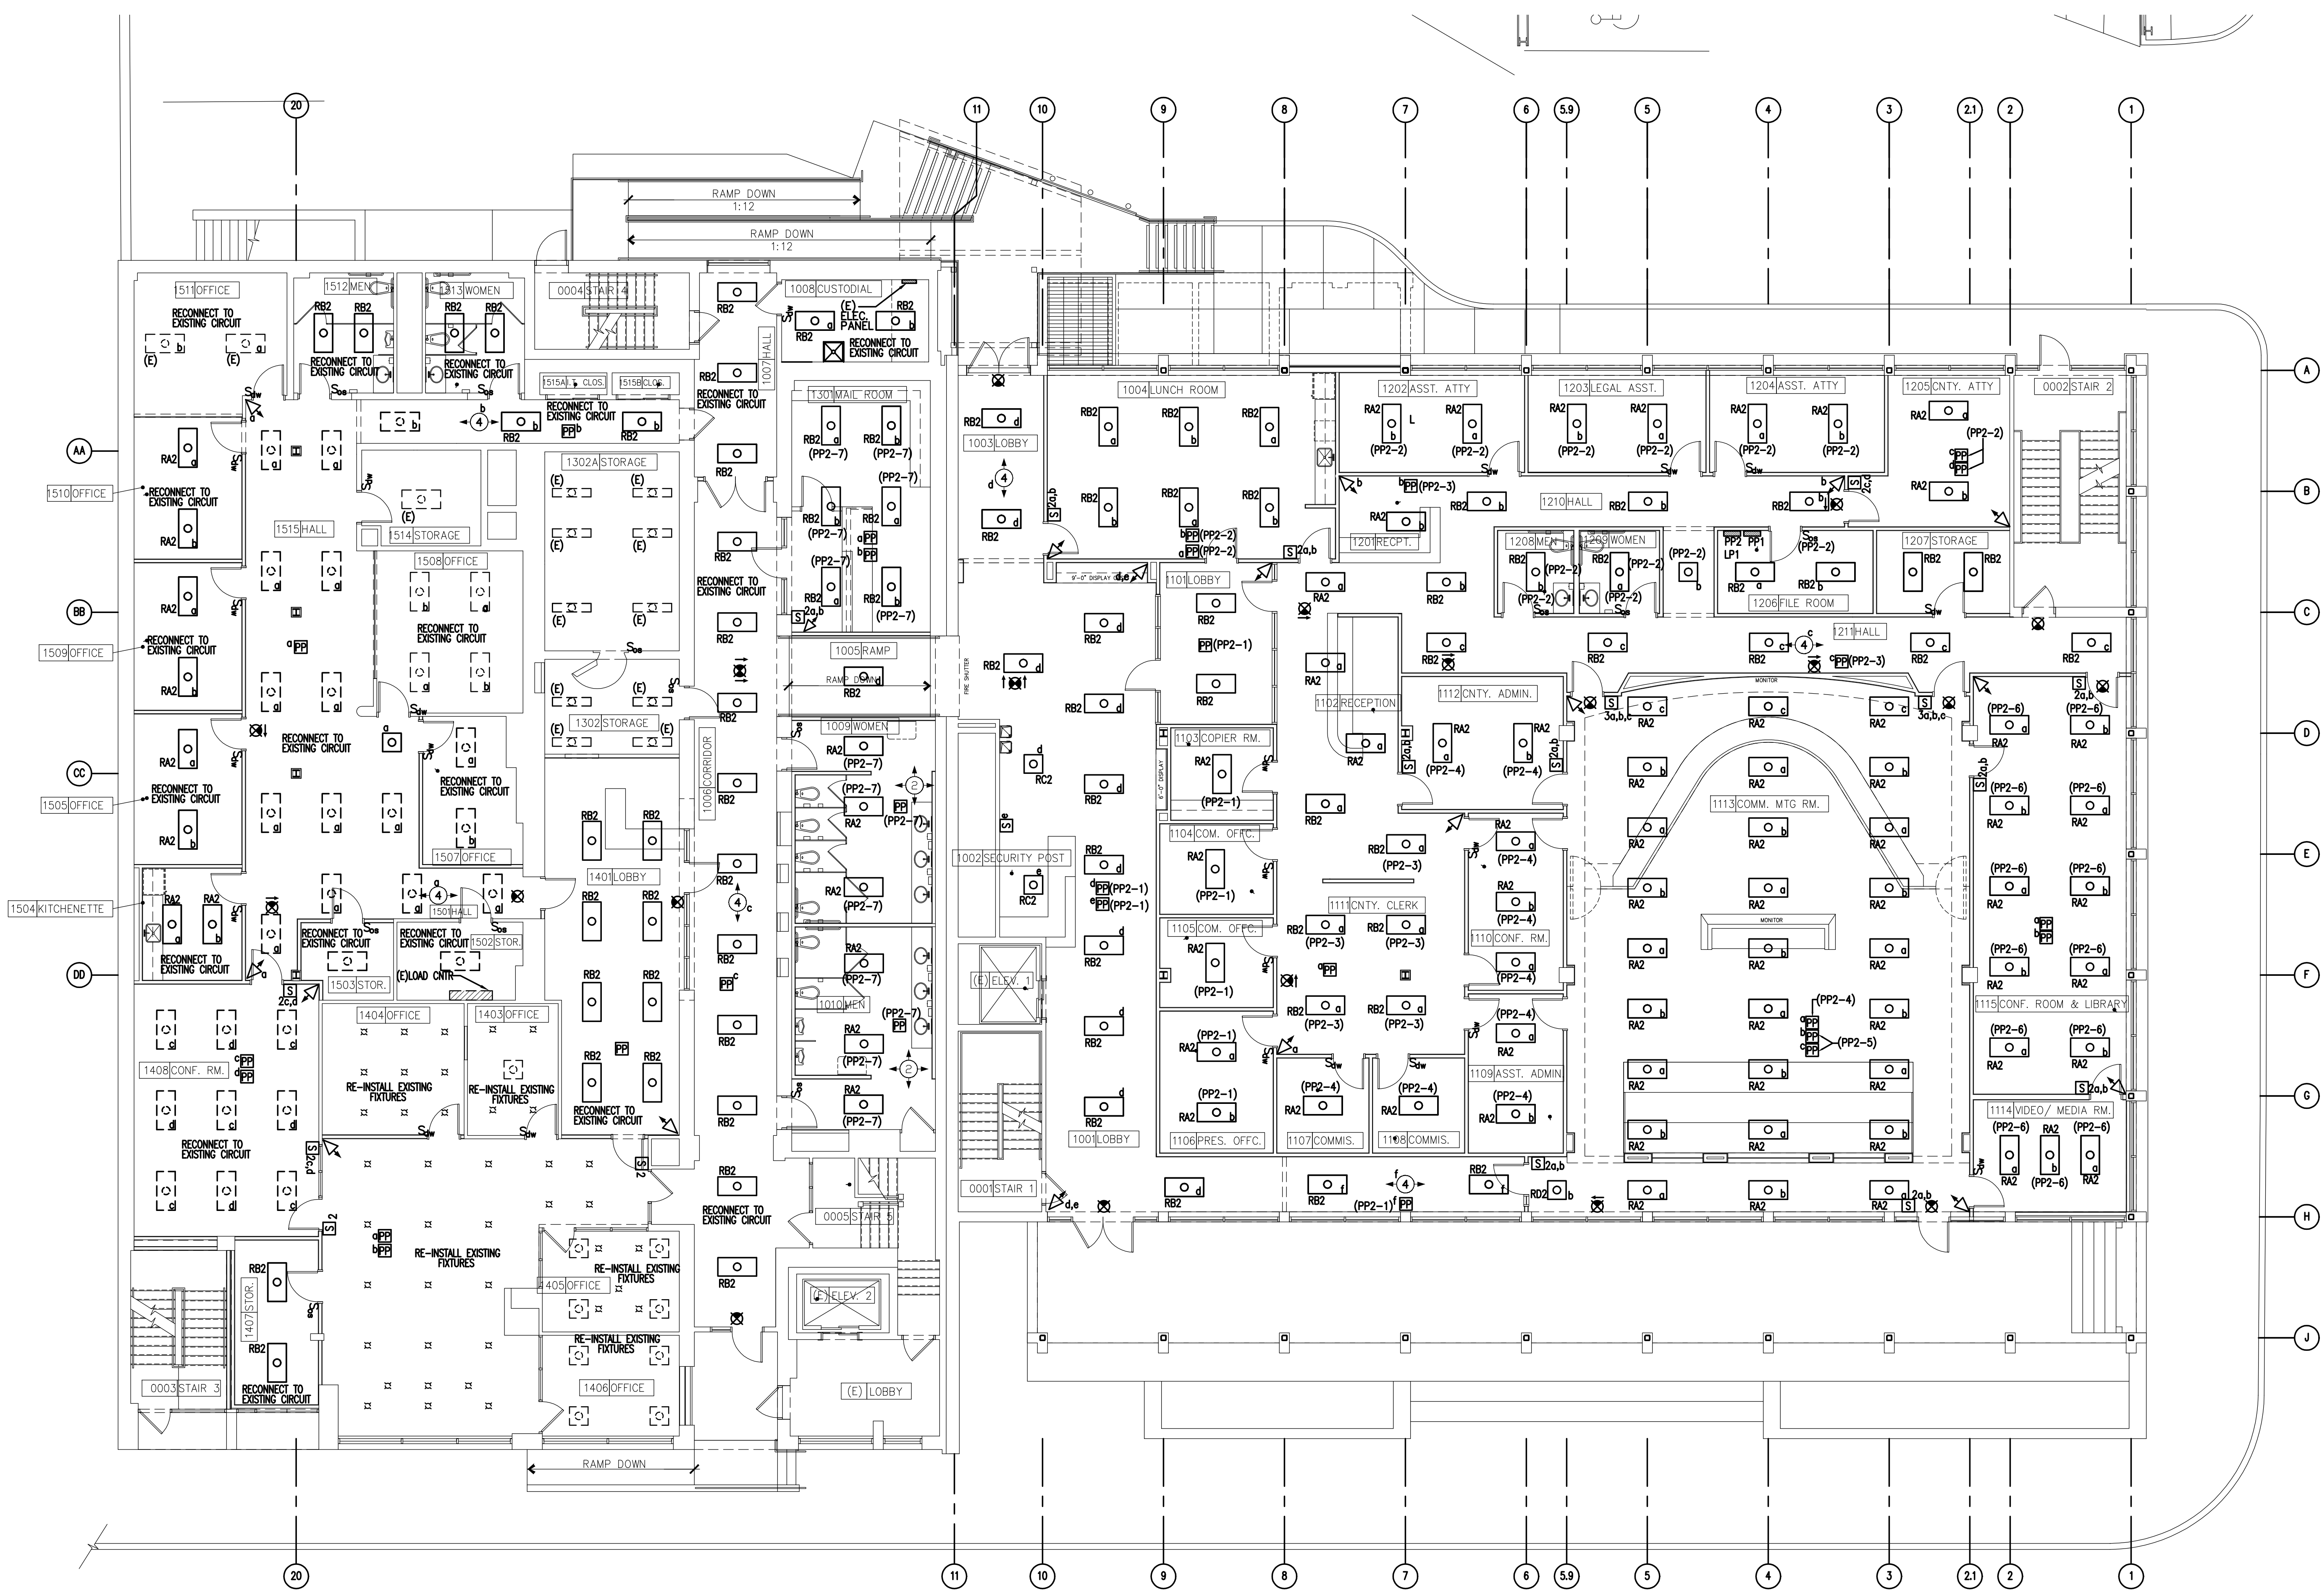

 FIRST FLOOR PLAN - LIGHTING
 SCALE: 1/8" = 1'-0"

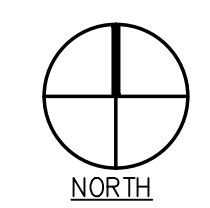

BUSHEY FEIGHT MORIN ARCHITECTS INC.
 473 North Potomac Street, Hagerstown, Md 21740
 301-733-5600 Fax 301-733-5612
 E-mail: BFM@BFMArchitects.com
 copyright 2014 - Bushey Feight Morin Architects, Inc.

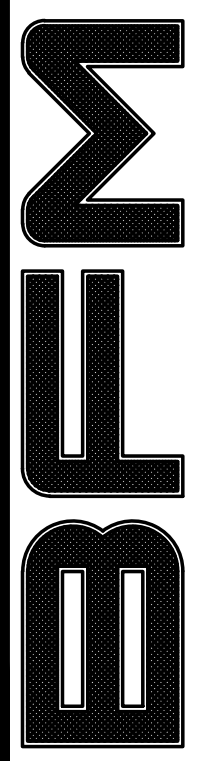

BFM No. 14028 WASH. CO. ADMINISTRATION COMPLEX
RHL No. 13208 FIRST FLOOR RENOVATIONS

BID DOCUMENTS
 FIRST FLOOR PLAN - LIGHTING
E2.1
 8 OF 14 SHEETS
 DATE : 08.15.14