 
 





RHL ENGINEERING COMPANY, INC.
 3 West Second Street
 Frederick, Md. 21701
 OFFICE: (301) 695-9424
 FAX: (301) 293-6338
 E-mail: rhleng@rhleng.com

Professional Certification. I hereby certify that these documents were prepared or approved by me, and that I am a duly licensed professional engineer under the laws of the State of Maryland. License No. 65511 Expiration Date: 06/03/2016




BUSHEY FEIGHT MORIN ARCHITECTS INC.
 473 North Potomac Street, Hagerstown, Md 21740
 301-733-5600 Fax 301-733-5612
 E-mail: BFM@BFMArchitects.com

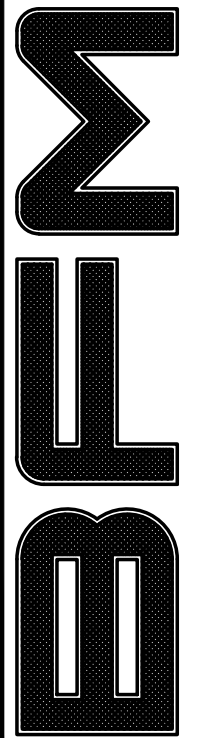

copyright 2014, Bushey Feight Morin Architects, Inc.
BUSHEY FEIGHT MORIN ARCHITECTS INC.
 WASH. CO. ADMINISTRATION COMPLEX
 RHL No. 13208 FIRST FLOOR RENOVATIONS

BID DOCUMENTS
 FIRST FLOOR PLAN - DEMO
P0.2
 2 OF 5 SHEETS
 DATE : 08.15.14

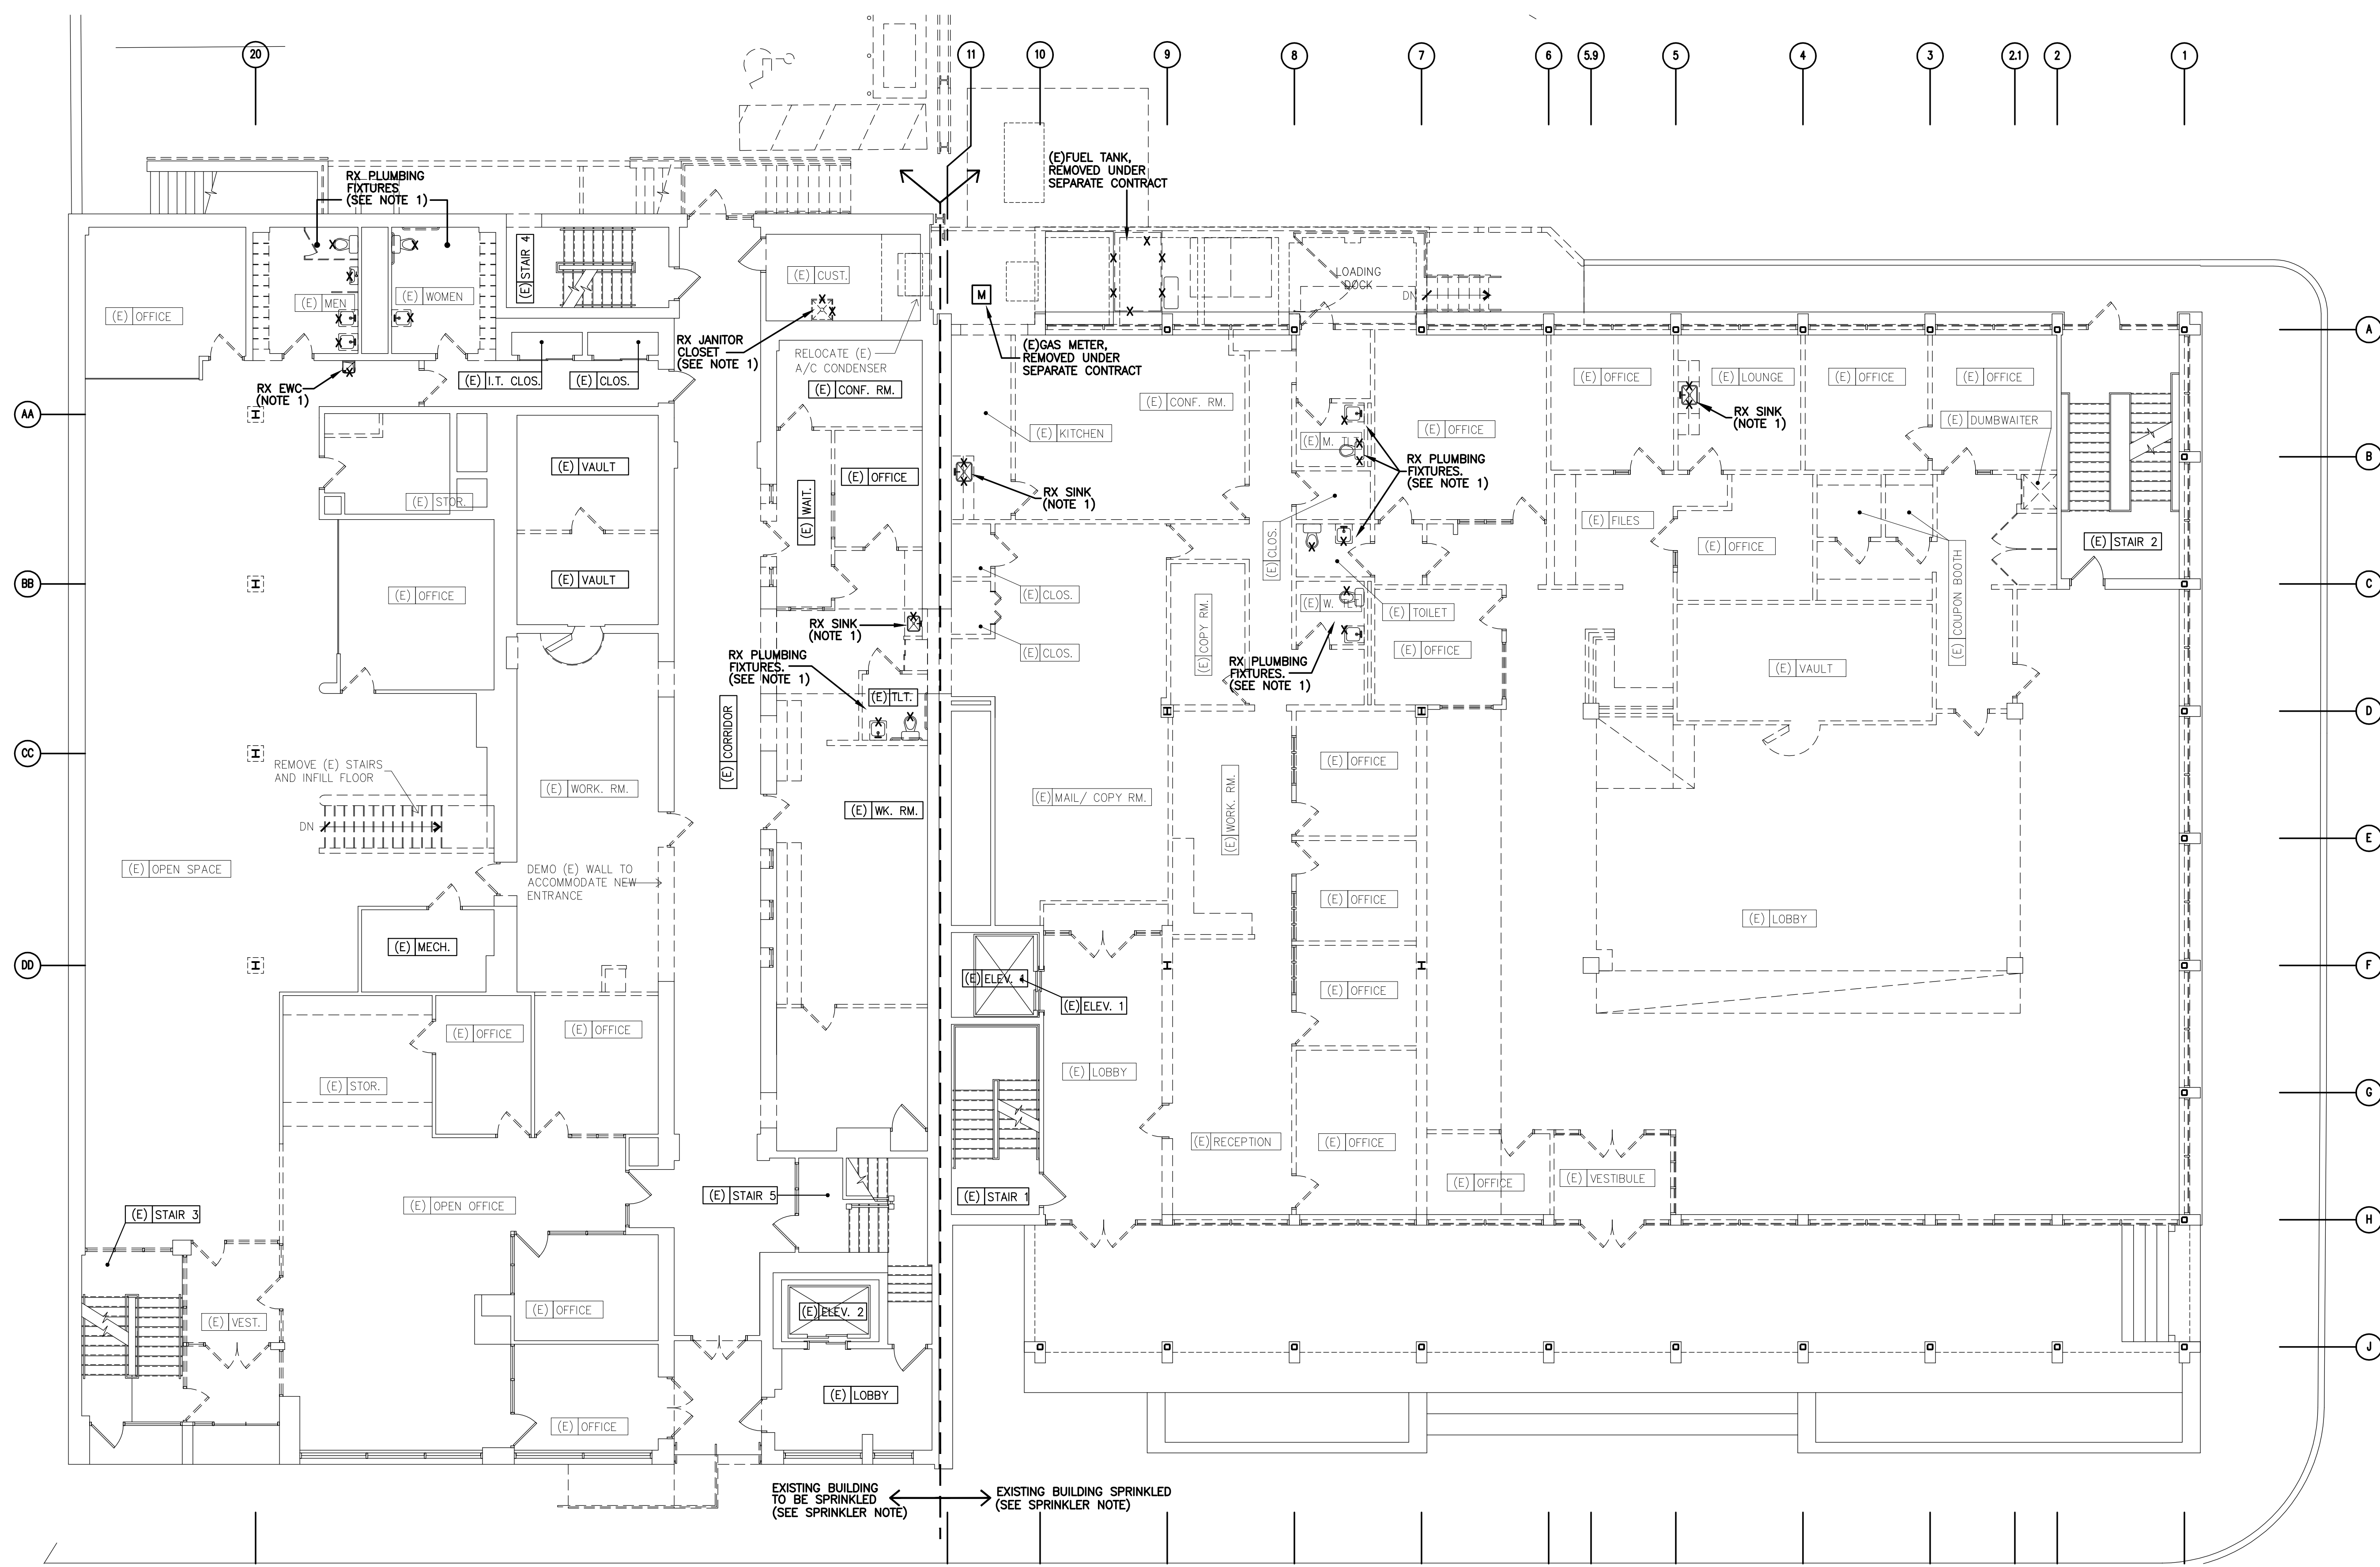

FIRST FLOOR PLAN DEMO - PIPING

SCALE: 1/8"=1'-0"
 NOTE 1: RX PLUMBING FIXTURES AND ALL ASSOCIATED PIPING TO ACCOMMODATE NEW TENANT WALL LAYOUT AS REQUIRED. PROVIDE SPRINKLER DRAWING TO FIRE MARSHAL. INSTALL PER NFPA 13 AND COORDINATE INSTALLATION WITH LOCAL FIRE MARSHAL. BLDG 120 TO RECEIVE NEW SPRINKLER ZONE FOR ALL FLOORS, BLDG 100 IS EXISTING TO BE MODIFIED.

SPRINKLER SYSTEM NOTE

NOTE: REVISE/EXTEND EXISTING SPRINKLER PIPE SYSTEM, MODIFY, RELOCATE PIPE, ADD HEADS AS NECESSARY TO ACCOMMODATE NEW TENANT WALL LAYOUT AS REQUIRED. PROVIDE SPRINKLER DRAWING TO FIRE MARSHAL. INSTALL PER NFPA 13 AND COORDINATE INSTALLATION WITH LOCAL FIRE MARSHAL. BLDG 120 TO RECEIVE NEW SPRINKLER ZONE FOR ALL FLOORS, BLDG 100 IS EXISTING TO BE MODIFIED.

