


Charles Washington Hall  
RENOVATIONS  
Corner of George & Washington Streets  
Charles Town, W.Va.

For the  
City of Charles Town  
City of Ranson

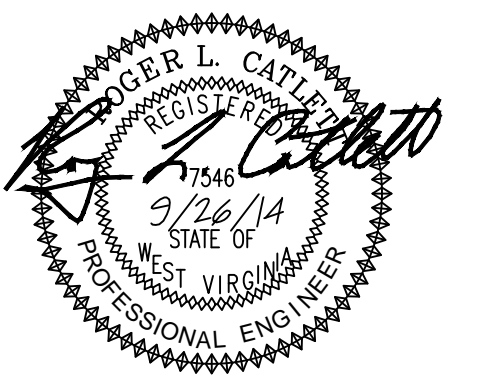

Planning & Engineering (prime)  
Hall Planning & Engineering, Inc  
316 Williams Street  
Tallahassee, FL 32303

Landscape Architecture  
Stromberg/Garrigan & Assoc., Inc.  
102 E. Main Street-The Penn Bldg  
Somerset, PA 15501

Historic Preservation & Architecture  
Landmarks SGA, LLC  
102 E. Main Street-The Penn Bldg  
Somerset, PA 15501


Structural Engineer  
R.L. Silman Associates  
1053 31st Street NW  
Washington D.C. 20007

Mech/Elect Engineer  
Comfort Designs  
620 Pennsylvania Avenue  
Winchester, VA 22601

Architect



Issue/Revision	Seal

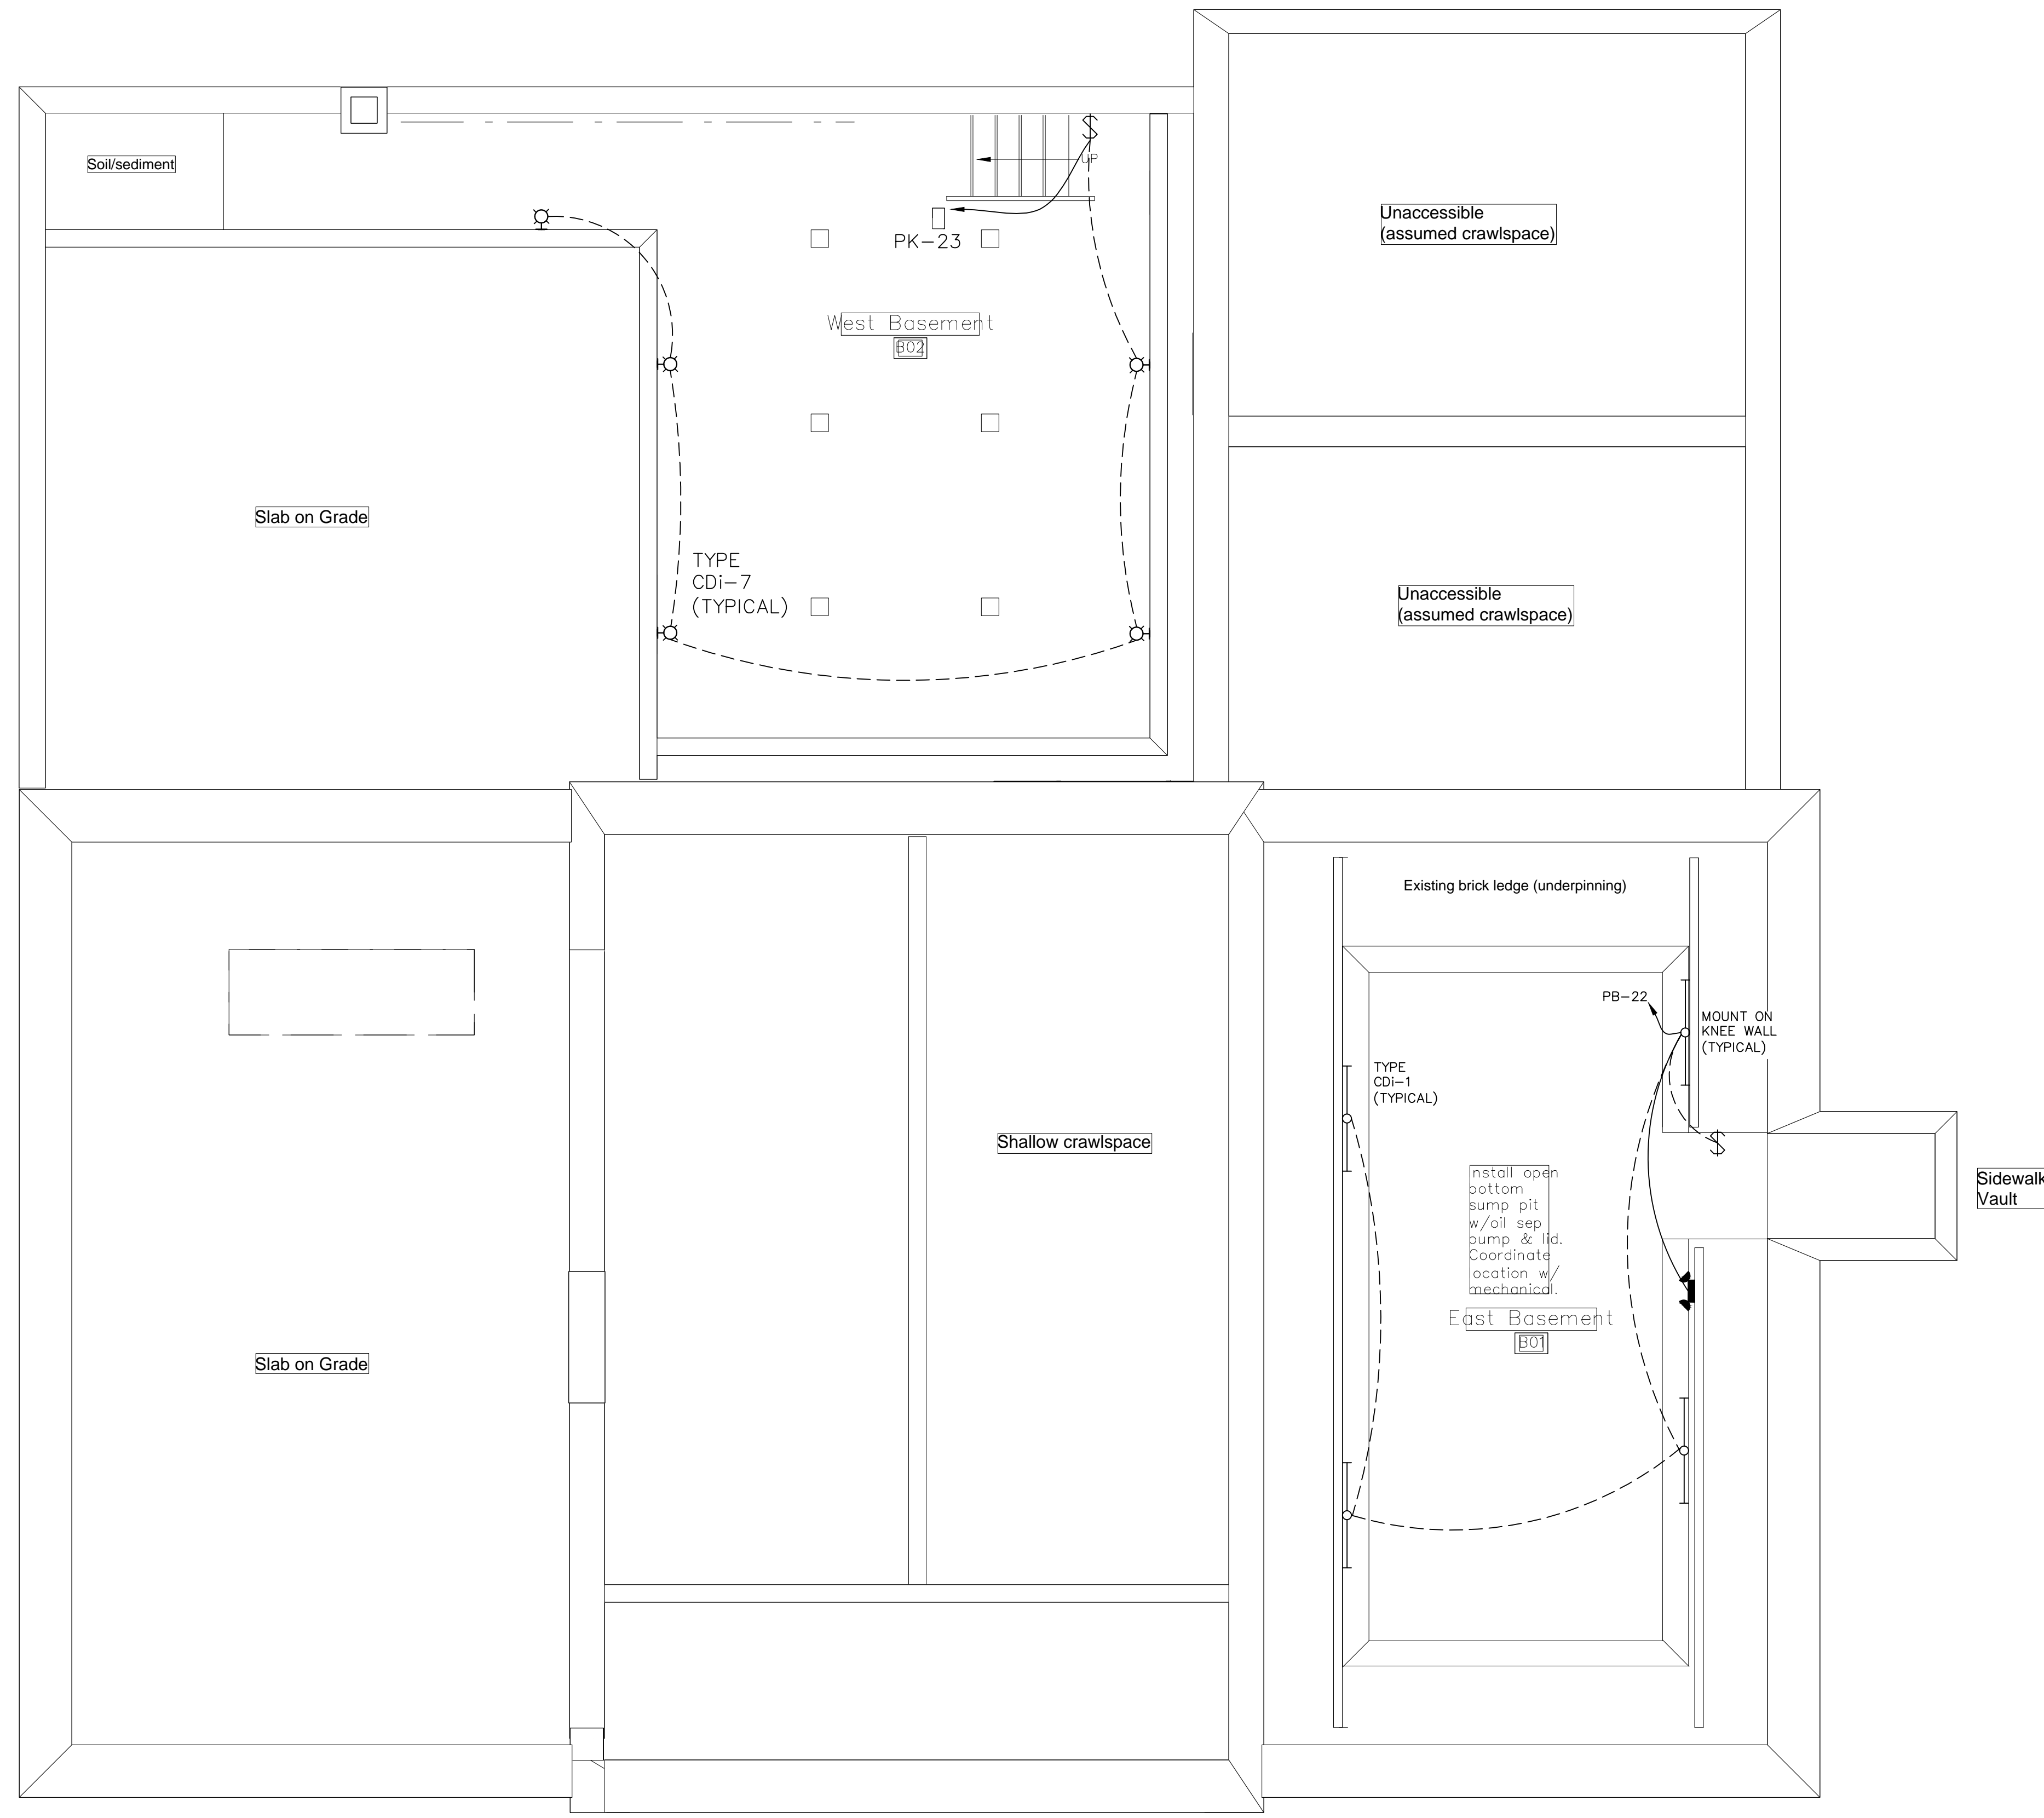

**DECORATIVE LIGHTING FIXTURE SCHEDULE**

MARK	MOUNT	TYPE	LAMPS	MANUFACTURER	MODEL
A	PENDANT	CLASSIC PENDANT	CREE BA19-110270MF 12DE26-2U100	REJUVENATION	ROSE CITY A4527 OP CO B7802 14
B	RECESSED	CAN DOWNLIGHT WITH LED LAMP	12W CR6 LED	CREE	CR6-800L WITH RC6 HOUSING
C	TRACK	LINE VOLTAGE LED TRACK LIGHTING (BLACK)	15W LED FLOOD	WAC LIGHTING	WAC LTK TRACK, 178 HEADS, 18W LED PAR 38 LAMPS
D	CEILING	60" INDUSTRIAL STYLE FAN & LIGHT	(2) CREE BA19-0807OMF 12DE26-2U100	CASA VIEJA	STYLE U4514-M2562
E	PENDANT	PARK AVENUE DISH FIXTURE	(1) CREE BA19-110270MF 12DE26-2U100	REJUVENATION	PARK AVENUE A4017 SHADE B0385
F1	WALL	WALL SCONCE (ST HELENS, PERIOD BASICS)	(1) CREE BA19-0807OMF 12DE26-2U100	REJUVENATION	A3409 SHADE 1550P GROUP 2 FINISH
F2	WALL	WALL SCONCE (PENDELTON, PERIOD BASICS)	(2) CREE BA19-0807OMF 12DE26-2U100	REJUVENATION	A4060 SHADE 1550P GROUP 2 FINISH
F3	WALL	WALL SCONCE (THREE FORKS, PERIOD BASICS)	(3) CREE BA19-0807OMF 12DE26-2U100	REJUVENATION	A0547 SHATE 1550P GROUP 2 FINISH
G	CEILING	CLOSE TO CEILING (JEFFERSON)	13W LED PER SOCKET	REJUVENATION	A8513 SHADE OP B7802 14
I	WALL	EMERGENCY EGRESS LIGHTING	6W XENON	LITHONIA	AFN DB EXT
J	CEILING	CUSTOM CHANDELIER	(48) CREE BA19-04527OMF 12DE26-2U100	CUSTOM	REFER TO ARCHITECTURAL DETAILS
K	RAILING	SEE TYPE CD6			
L	GROUND	IN GROUND LIGHTING	100W MH E17	ALLSCAPE	SL-43HPBB-120-100WMH-E17 STAINLESS OPTICS WW2
M	GOOSENECK	ORNAMENTAL LANTERN	CREE BA19-110270MF	ALLSCAPE	DOMINION BLACK PORCELAIN 16" DIA. E26 SOCKET E17 ELECTRIC/GOODRICH G36 GOOSENECK (BLACK) GUARD (875) AND FROSTED GLASS

**FIXTURE SCHEDULE**

MARK	MOUNT	TYPE	LAMPS	MANUFACTURER	MODEL
CD1	SURFACE	STRIP LIGHT WITH WIRE GUARD	(2) 32 T8	LITHONIA	C 2 32 MVOLT GEB10IS WGCUN NST
CD2	CEILING/WALL	EDGE LIT EXIT LIGHT EMERGENCY OPERATION	LED	LITHONIA	EDG 1 R EL
CD3	CEILING/WALL	RECESSED EMERGENCY LIGHTING UNIT	18W	LITHONIA	ELR2
CD4	WALL	WALL MOUNTED EMERGENCY LIGHT	LED	LITHONIA	ELM2 LED
CD5	WALL	EXTERIOR EMERGENCY EGRESS	6W XENON	LITHONIA	AFN DB EXT
CD6	UNDER RAILING	EXTERIOR EMERGENCY EGRESS LIGHTING	LED	KLIK	LEDP0D (LED SPACING 10" FOR LENGTH OF RAIL)
CD7	WALL	UTILITY LIGHT	CREE BA19 08027 OMF 12DE26-2U100	LITHONIA	VW1501
CD8	CEILING	ENCLOSED FOUR PROC FLUORESCENT	(2) 32 T8	LITHONIA	EFS 2 32 MVOLT GEB10IS
CD9	CABLE	FESTOON LIGHTING	(10) 15W INC / CORD	OOGA LIGHTS (WEB)	21" COMMERCIAL LINEAR LIGHT STRAND STAND
CD10	WALL	WALL	(2) 18W LED PAR 38	GENERIC	DUAL HEAD FLOODLIGHT
CD11	WALL	WALL PACK	ONE LED ENGINE	LITHONIA	TWP 10C 700 50K T3M MVOLT DDBXD
CD12	UNDER COUNTER	LED UNDERCOUNTER LIGHTING	LED	LSI	LDL2 XX LED CW 24 DL (LENGTH TO BE DETERMINED)

BASEMENT LIGHTING PLAN  
1  
E1-1/1/4" = 1'-0"

Drawing Title  
**BASEMENT LIGHTING PLAN**

Date 9/28/14  
Scale  
Project Number 11105  
Drawing Number

**E1.1**