


SEE DIFFUSER/REGISTER SCHEDULE FOR BRANCH RUNOUT SIZES TYPICAL

New primed metal steps handdrilling

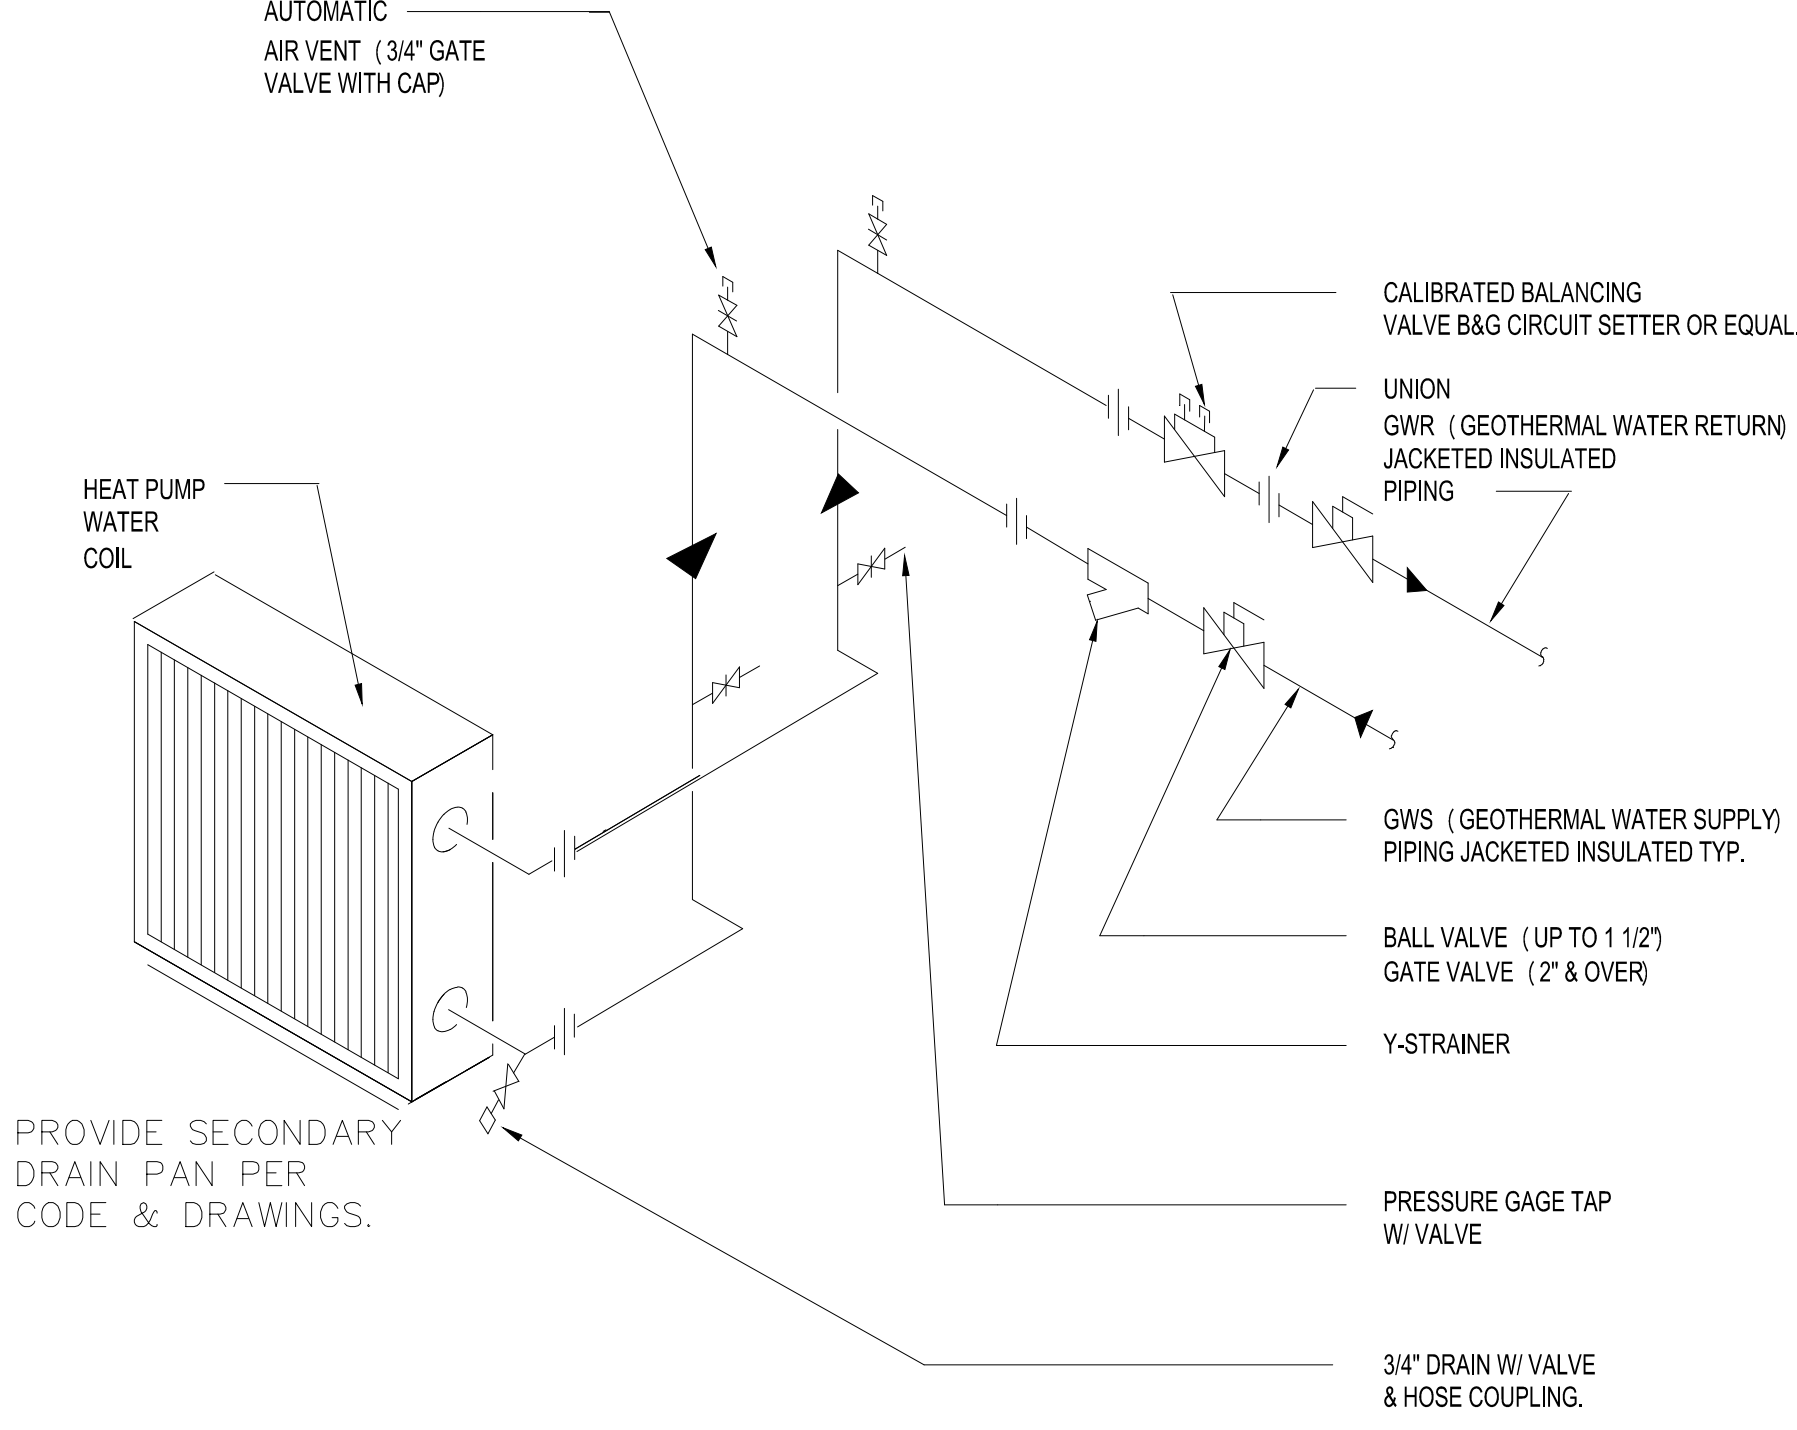


HEAT PUMP WATER COIL PIPING

NOT TO SCALE

Basement Mechanical Plan

Scale: 1/4" = 1'0"

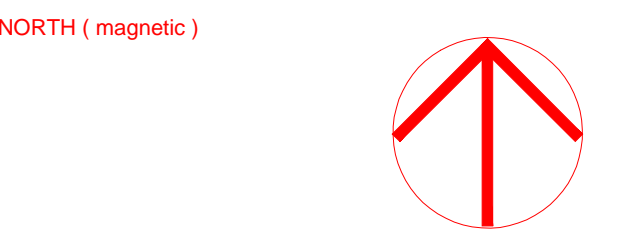

Charles Washington Hall
RENOVATIONS
 Corner of George & Washington Streets
 Charles Town, W.Va.

For the
 City of Charles Town
 City of Ranson

Planning & Engineering (prime)
 Hall Planning & Engineering, Inc
 316 Williams Street
 Tallahassee, FL 32303

Landscape Architecture
 Stromberg/Garrigan & Assoc., Inc.
 102 E. Main Street-The Penn Bldg
 Somerset, PA 15501

Historic Preservation & Architecture
 Landmarks SGA, LLC
 102 E. Main Street-The Penn Bldg
 Somerset, PA 15501

Structural Engineer
 R.L. Silman Associates
 1053 31st Street NW
 Washington D.C. 20007

Mech/Elect Engineer
 Comfort Design, Inc.
 620 Pennsylvania Avenue
 Winchester, VA 22601

Architect
GROVE & DALL'OLIO
 ARCHITECTS PLLC
 220 WEST KING • MARTINSBURG, WEST VIRGINIA • 25401

Issue/Revision	Seal

Drawing Title
Basement Mechanical Plan

Date 9/26/14
 Scale 1/4"=1'0" Project Number 11105
 Drawing Number

M2.1