


NORTH (magnetic)

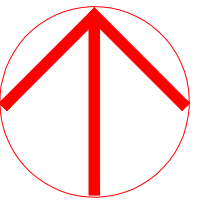

Charles Washington Hall RENOVATIONS

Corner of George & Washington Streets
Charles Town, W.Va.

For the
City of Charles Town
City of Ranson

Planning & Engineering (prime)
Hall Planning & Engineering, Inc
316 Williams Street
Tallahassee, FL 32303

Landscape Architecture
Stromberg/Garrigan & Assoc., Inc.
102 E. Main Street-The Penn Bldg
Somerset, PA 15501

Historic Preservation & Architecture
Landmarks SGA, LLC
102 E. Main Street-The Penn Bldg
Somerset, PA 15501

Structural Engineer
R.L. Silman Associates
1053 31st Street NW
Washington D.C. 20007

Mech/Elect Engineer
Comfort Design, Inc.
620 Pennsylvania Avenue
Winchester, VA 22601


Architect



Issue/Revision	Seal

Drawing Title
**First Floor Level
Condenser Water
Piping Plan**
Date 9/26/14
Scale 1/4"=1'0" Project Number 11105
Drawing Number

M3.2

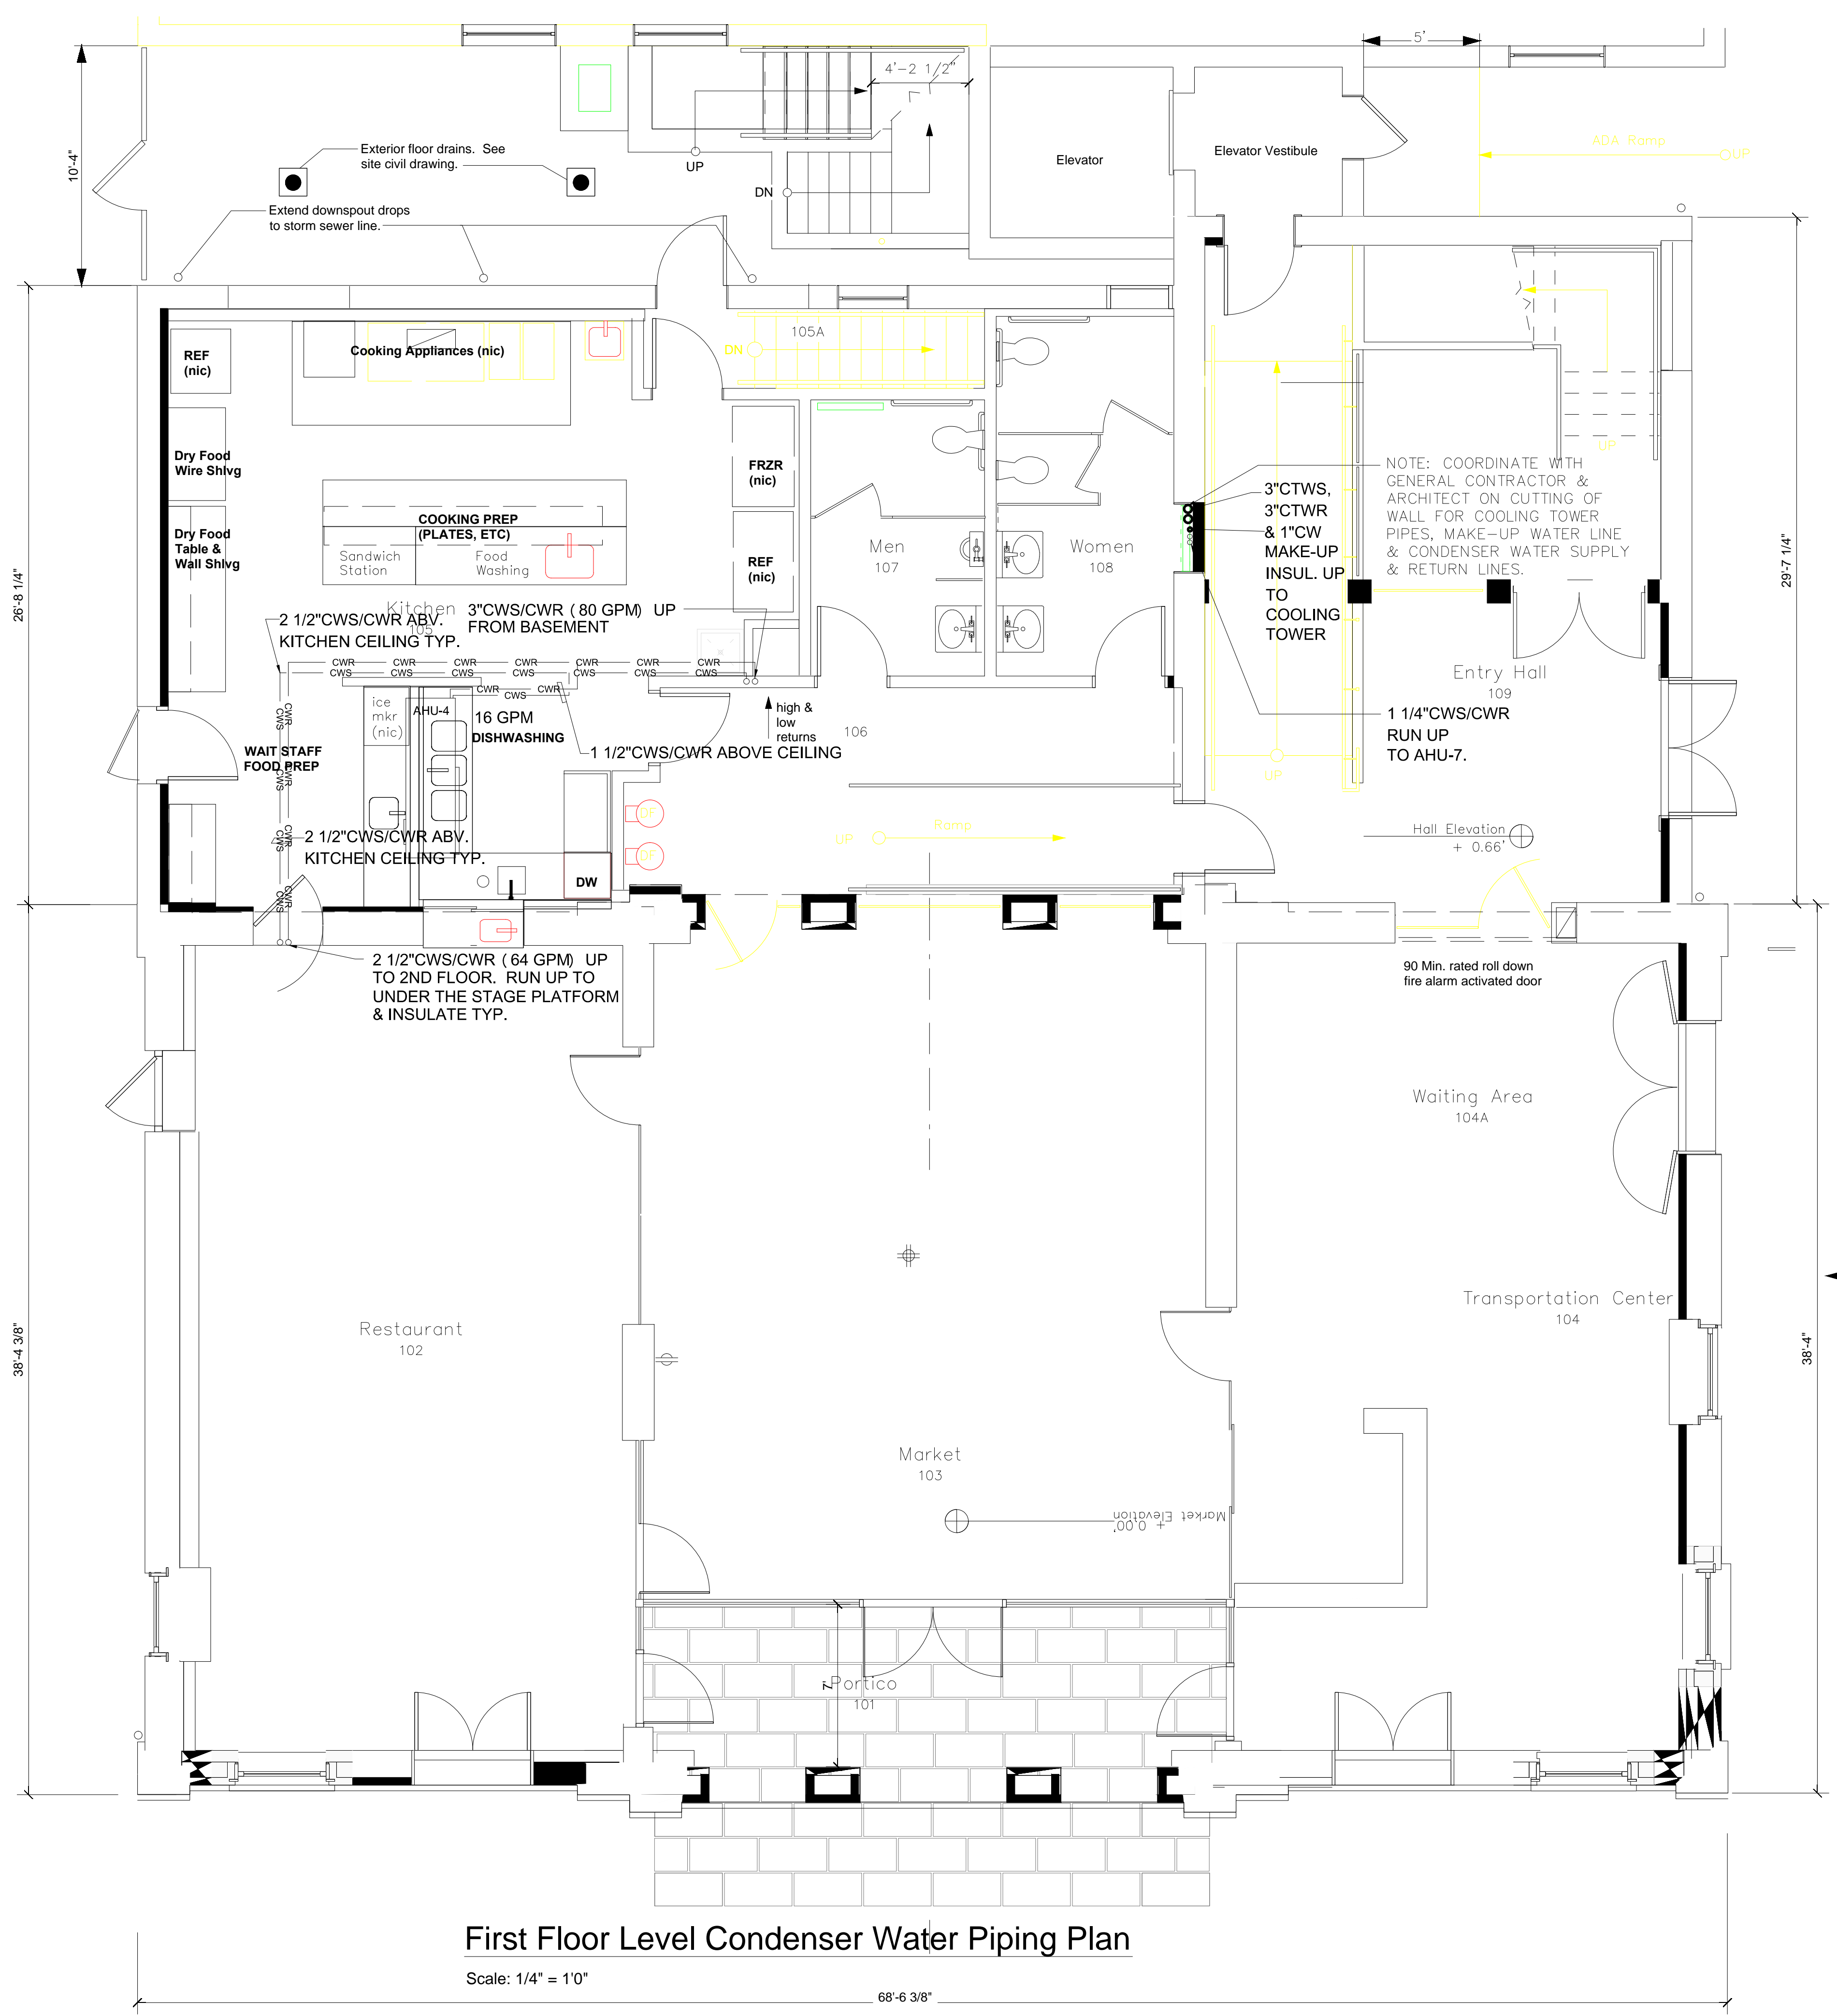

First Floor Level Condenser Water Piping Plan

Scale: 1/4" = 1'0"

68'-6 3/8"