


NORTH (magnetic)

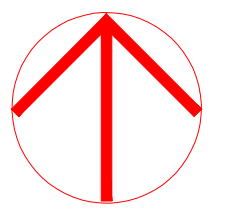

# Charles Washington Hall RENOVATIONS

Corner of George & Washington Streets  
Charles Town, W.Va.

For the  
City of Charles Town  
City of Ranson

Planning & Engineering (prime)  
Hall Planning & Engineering, Inc  
316 Williams Street  
Tallahassee, FL 32303

Landscape Architecture  
Stromberg/Garrigan & Assoc., Inc.  
102 E. Main Street-The Penn Bldg  
Somerset, PA 15501

Historic Preservation & Architecture  
Landmarks SGA, LLC  
102 E. Main Street-The Penn Bldg  
Somerset, PA 15501

Structural Engineer  
R.L. Silman Associates  
1053 31st Street NW  
Washington D.C. 20007

Mech/Elect Engineer  
Comfort Design, Inc.  
620 Pennsylvania Avenue  
Winchester, VA 22601

Architect







Issue/Revision	Seal

Drawing Title

## Basement Water & Gas Piping Plan

Date 9/26/14  
Scale 1/4"=1'0" Project Number 111105  
Drawing Number

# P3.1

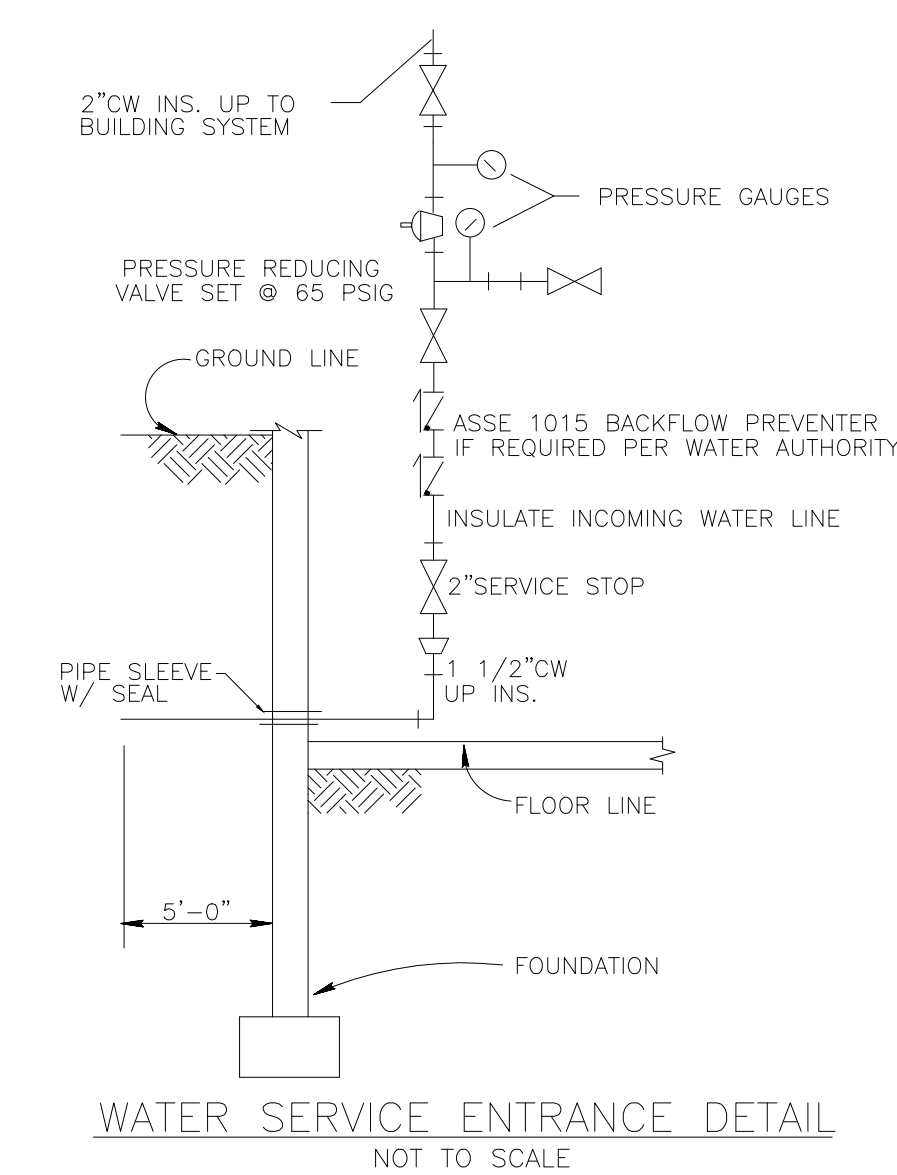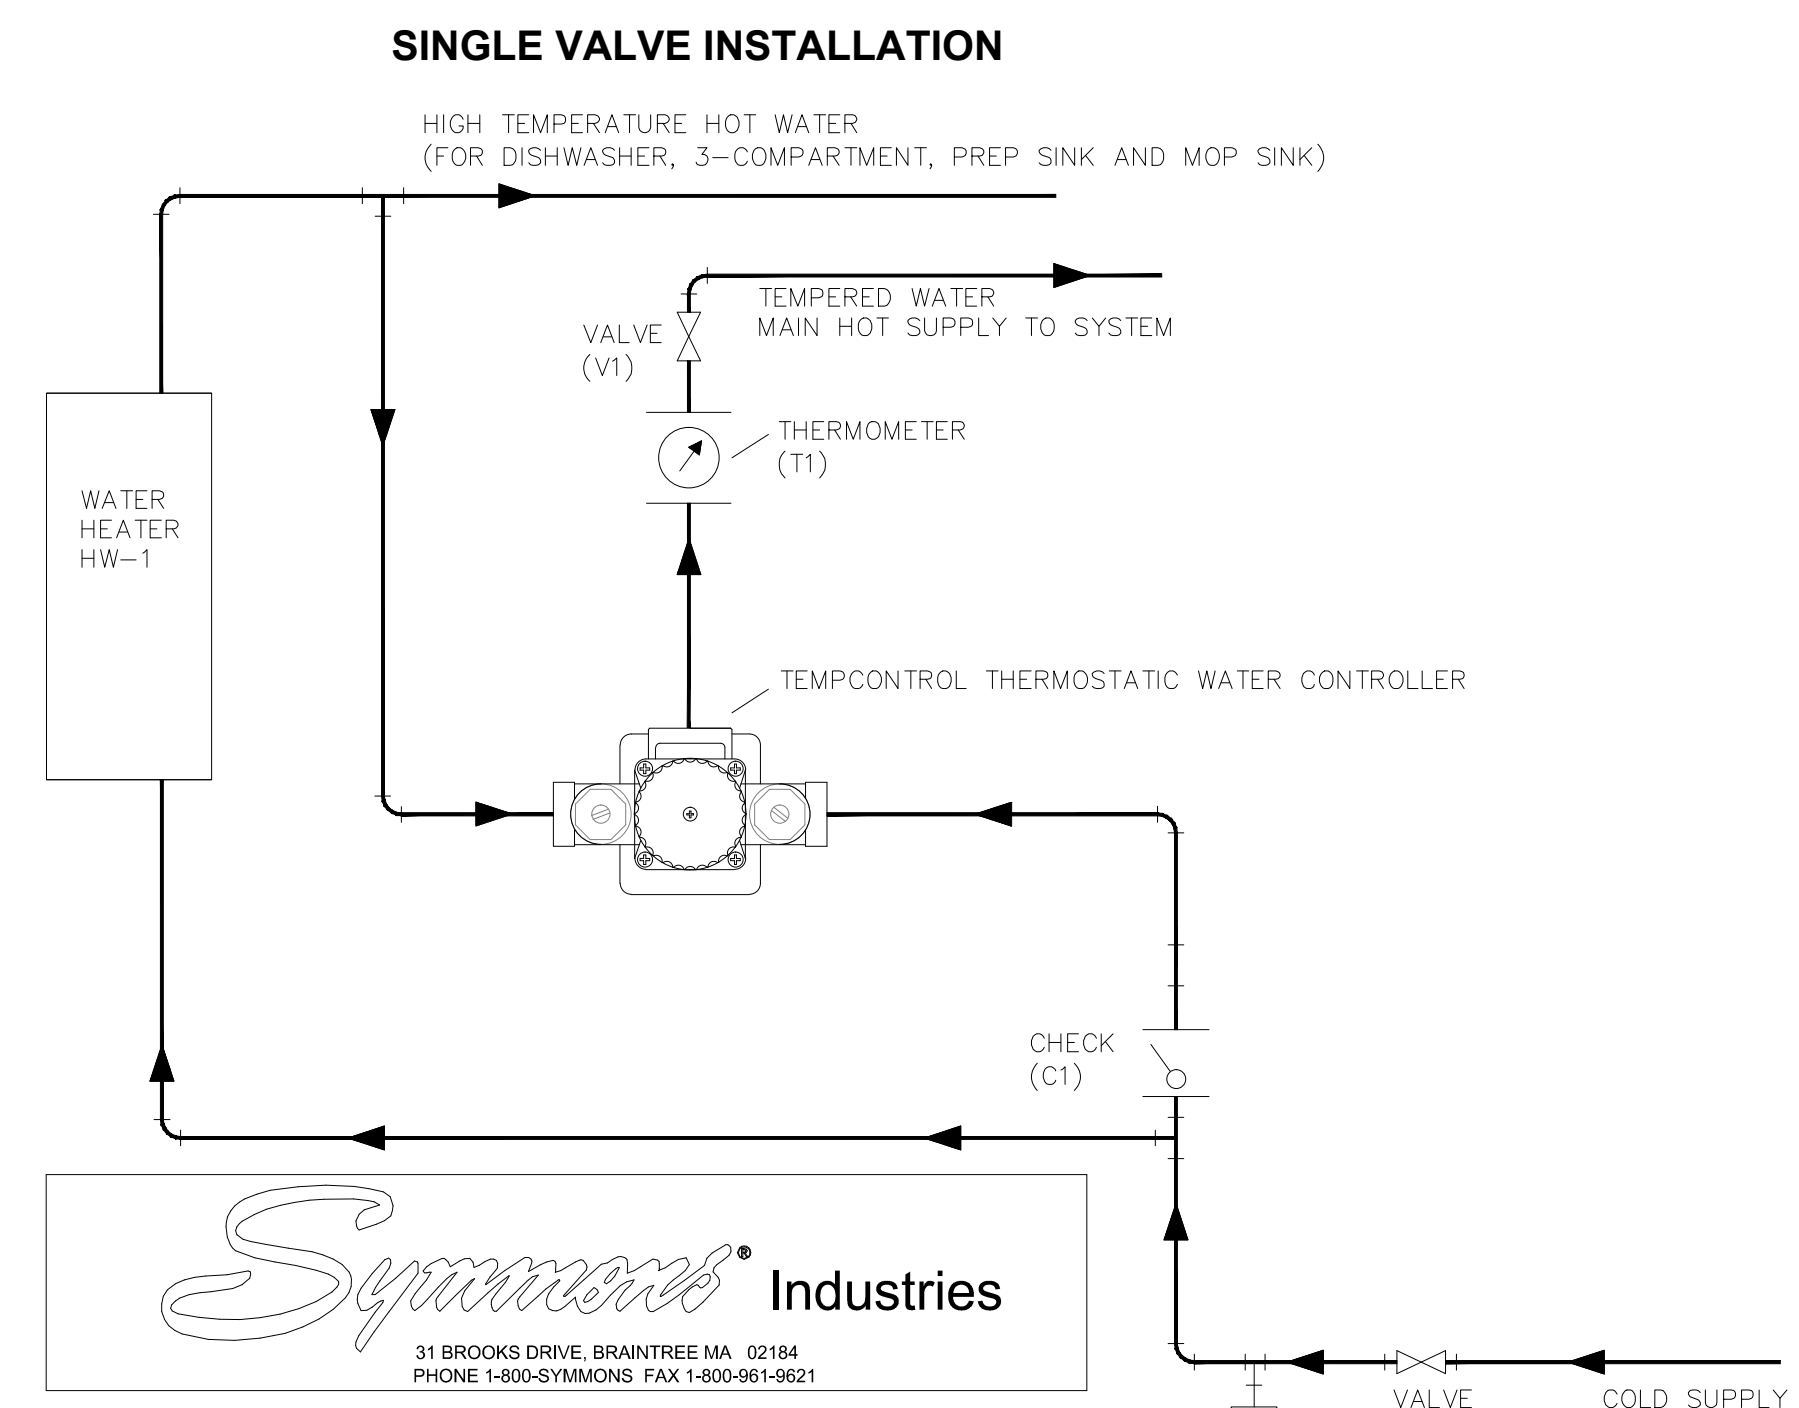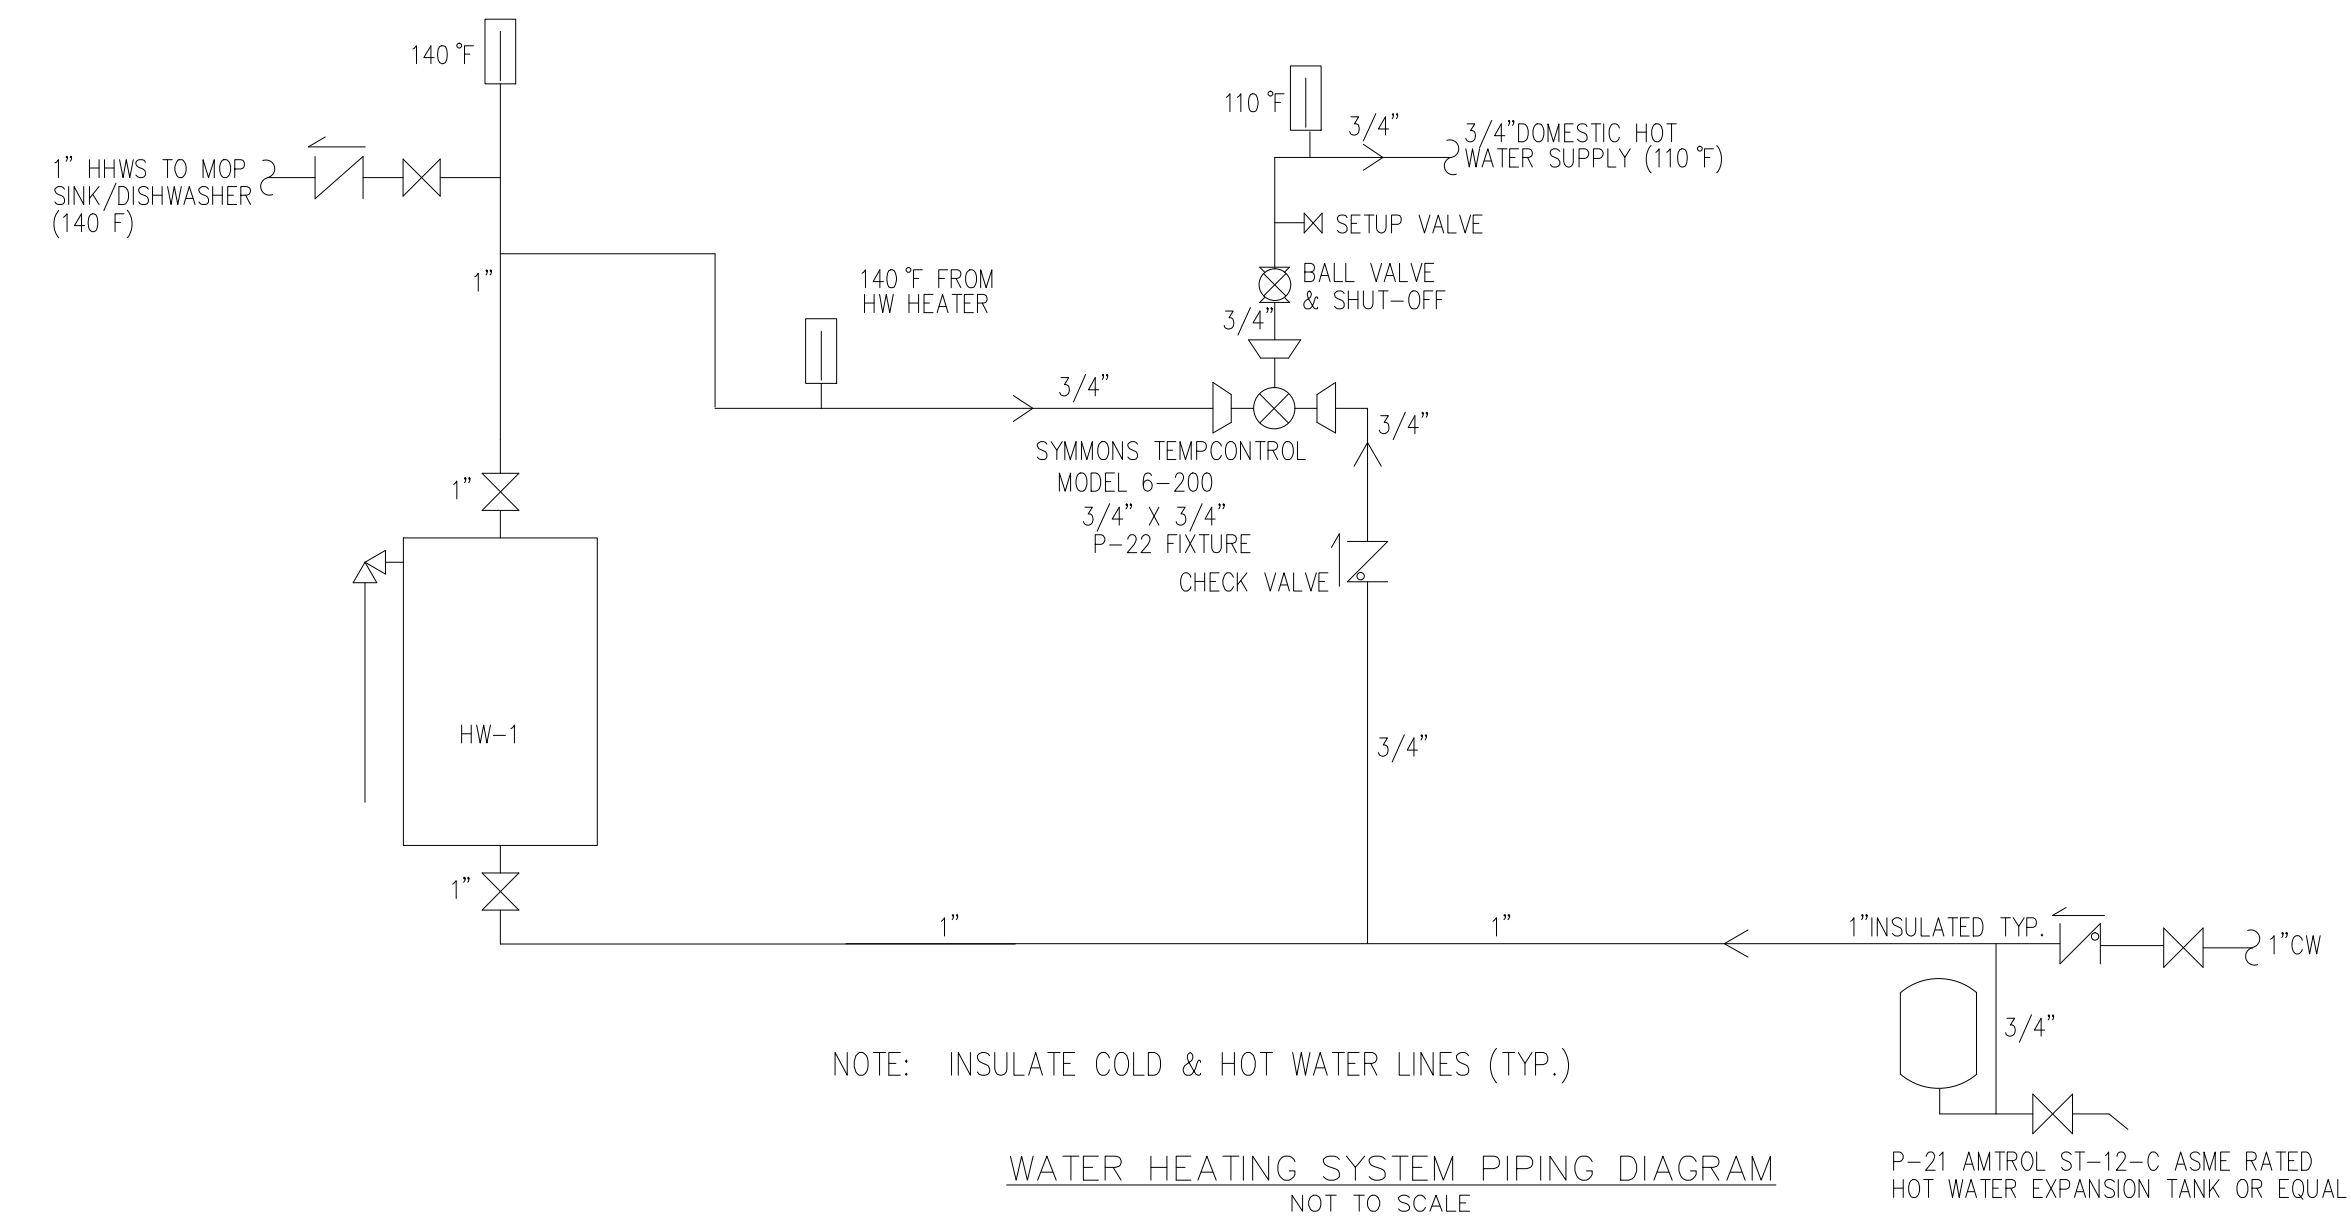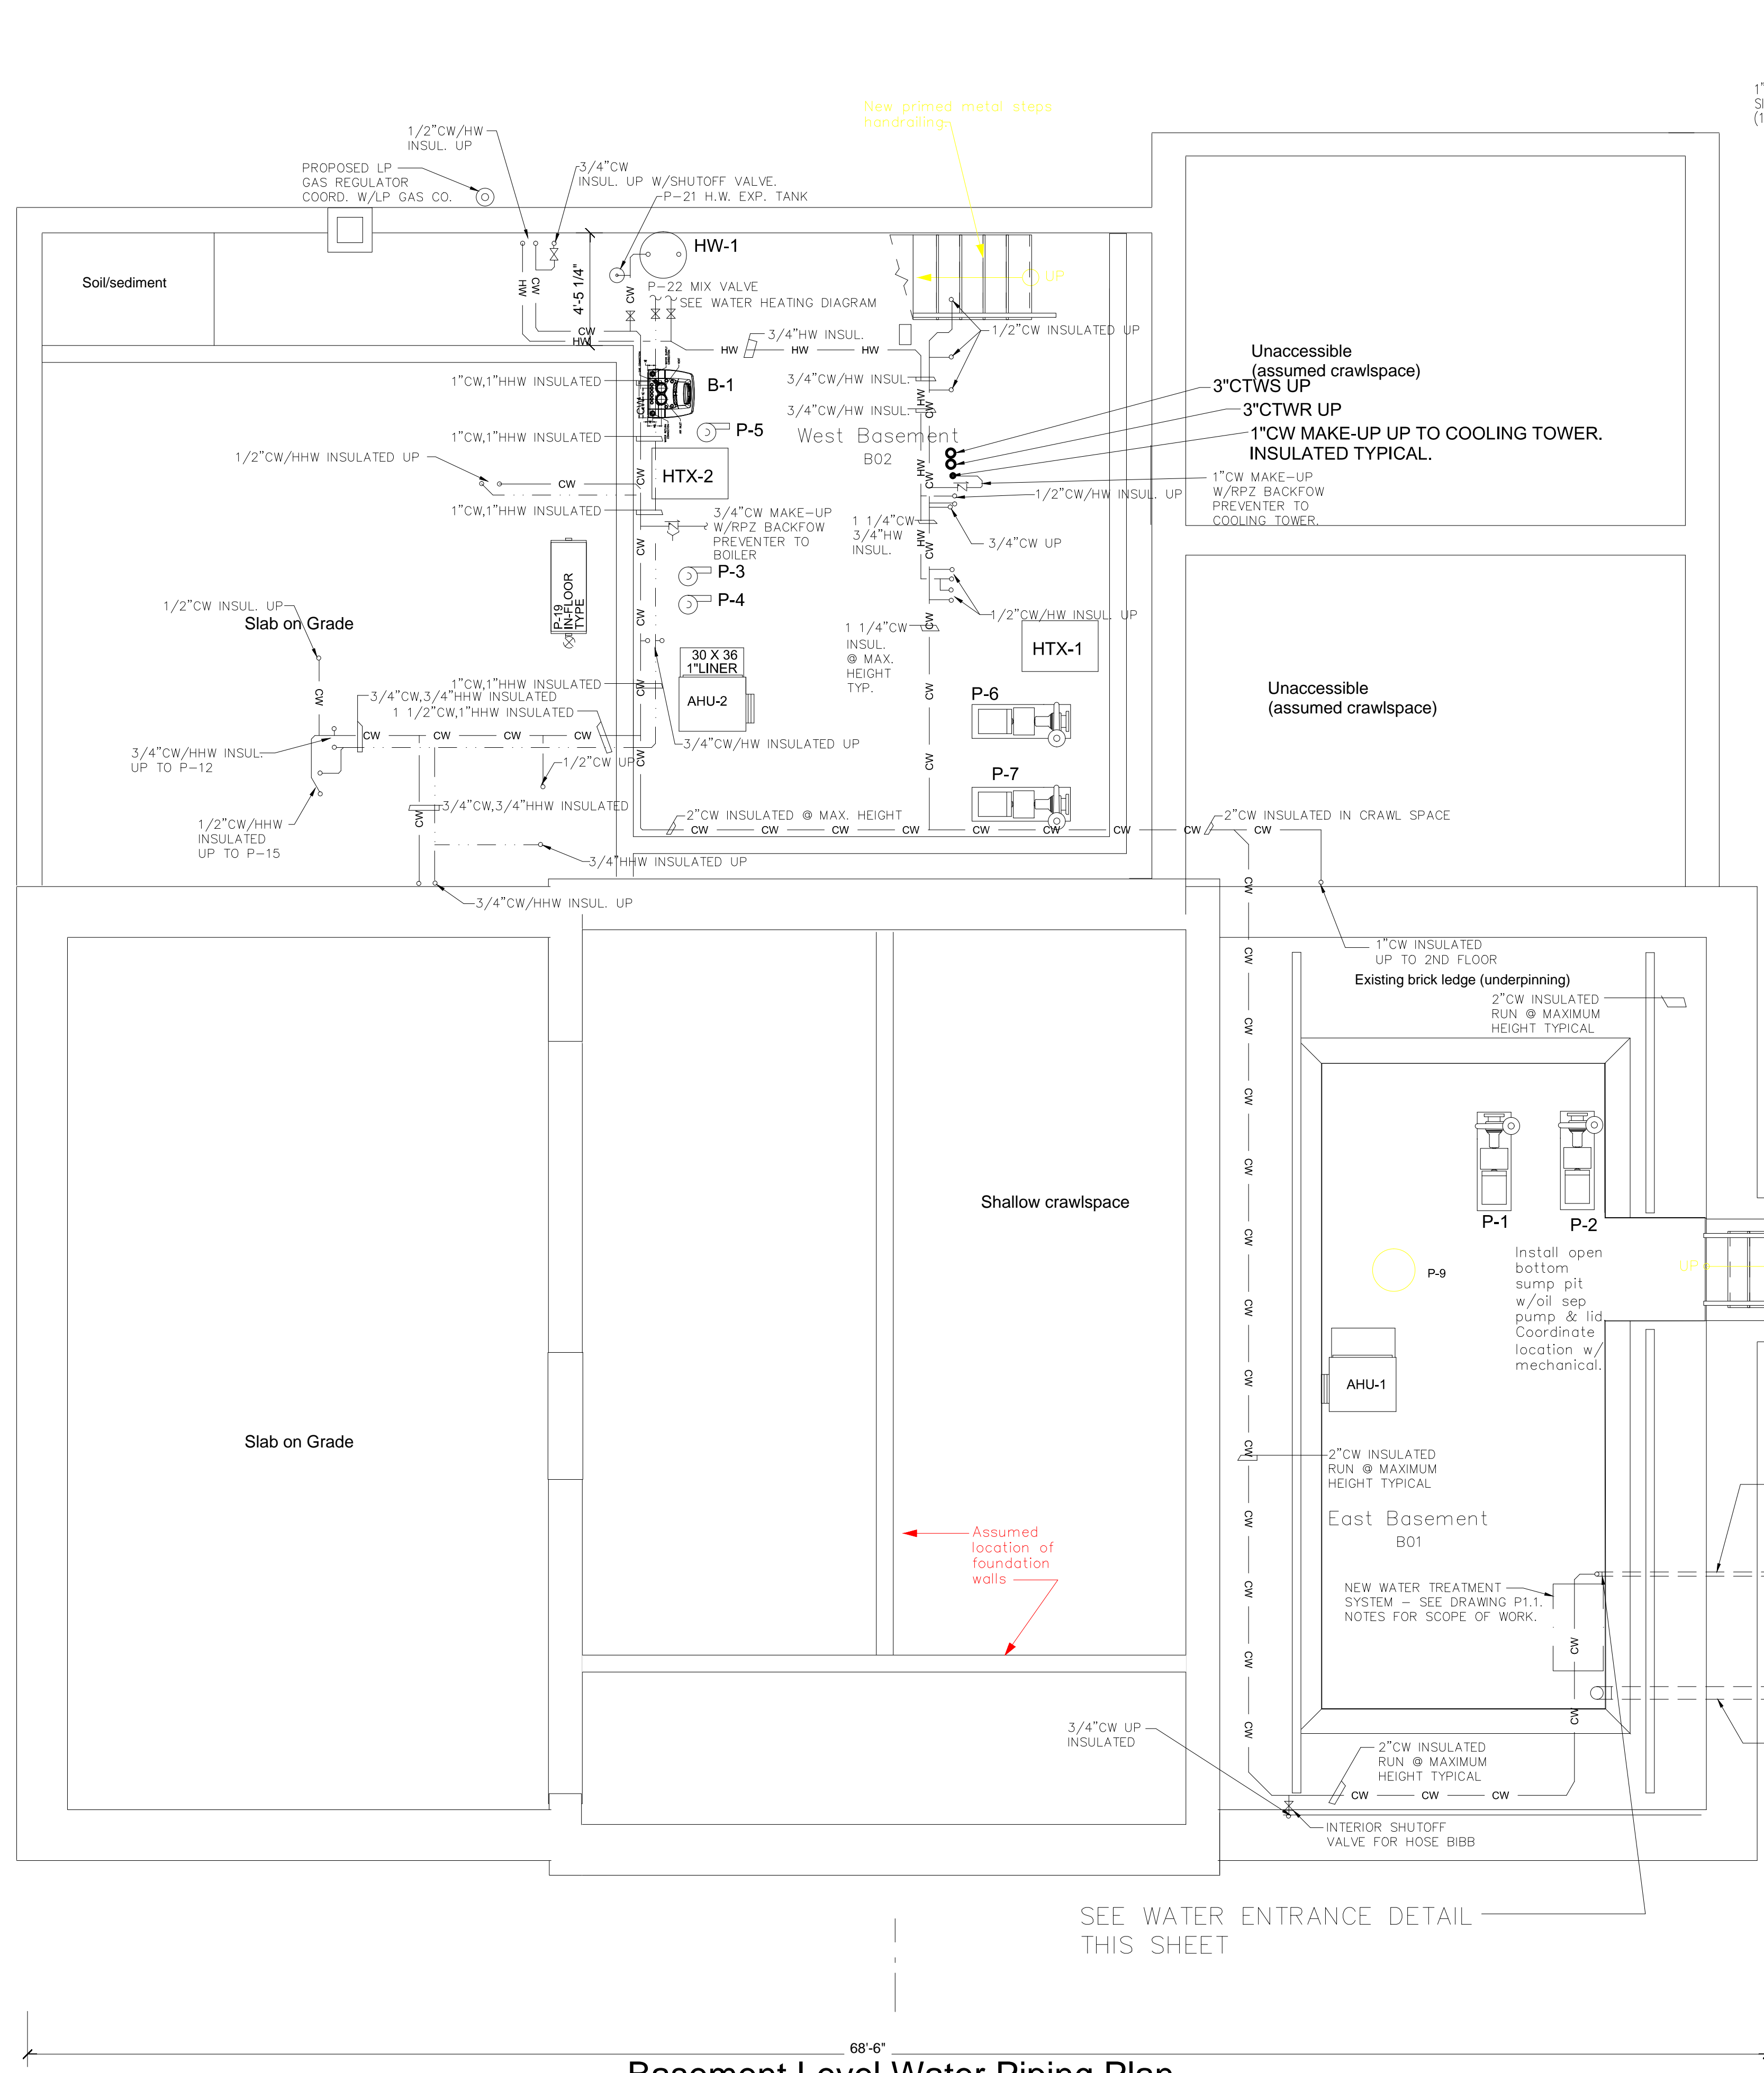

**Basement Level Water Piping Plan**  
Scale: 1/4" = 1'0"