


Charles Washington Hall
RENOVATIONS
Corner of George & Washington Streets
Charles Town, W.Va.

For the
City of Charles Town
City of Ranson

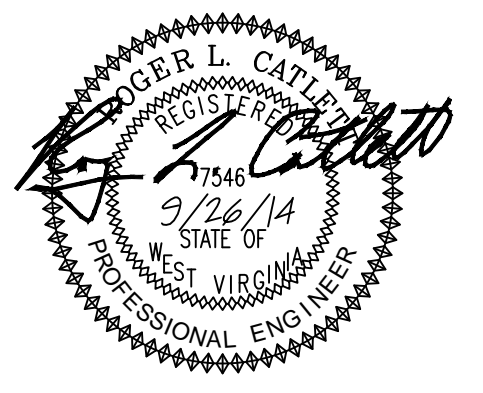

Planning & Engineering (prime)
Hall Planning & Engineering, Inc
316 Williams Street
Tallahassee, FL 32303

Landscape Architecture
Stromberg/Garrigan & Assoc., Inc.
102 E. Main Street-The Penn Bldg
Somerset, PA 15501

Historic Preservation & Architecture
Landmarks SGA, LLC
102 E. Main Street-The Penn Bldg
Somerset, PA 15501

Structural Engineer
R.L. Silman Associates
1053 31st Street NW
Washington D.C. 20007

Mech/Elect Engineer
Comfort Designs
620 Pennsylvania Avenue
Winchester, VA 22601

Architect




Issue/Revision	Seal

Drawing Title


2ND FLOOR LIGHTING PLAN

Date 9/26/14
Scale Project Number 11105
Drawing Number


E1.3

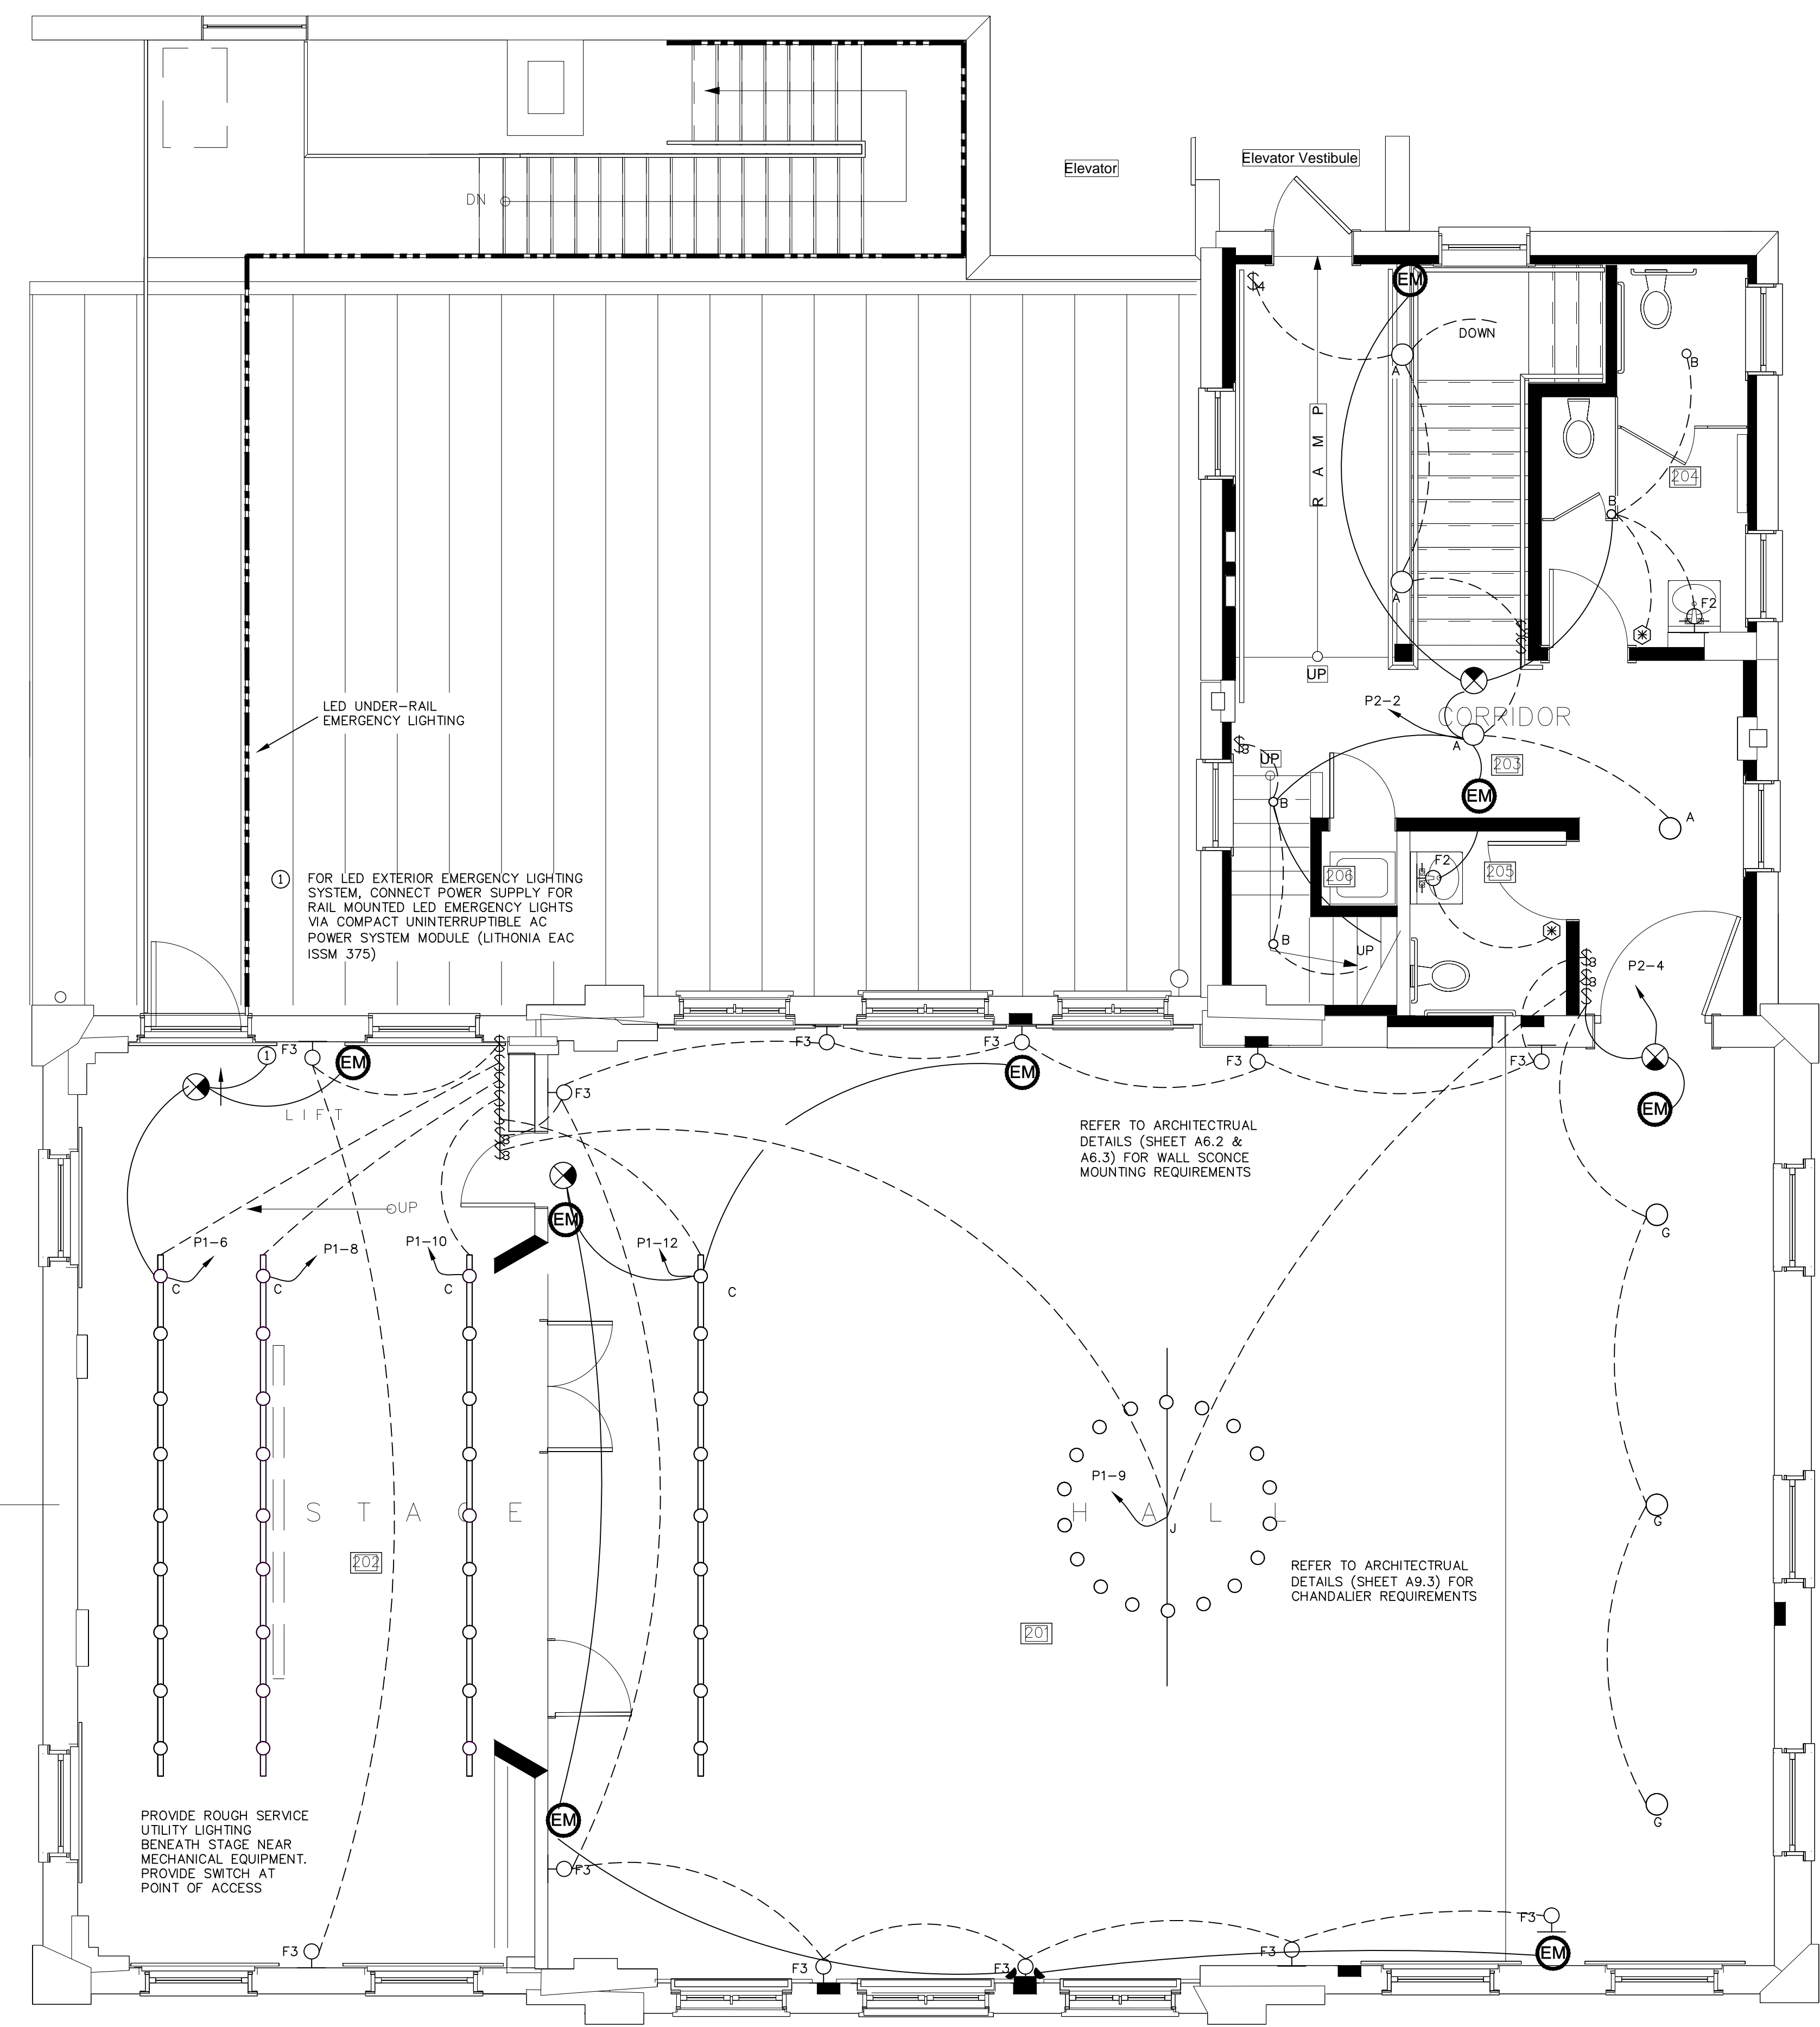

2ND FLOOR LIGHTING PLAN
1
E1-3 1/4" = 1'-0"

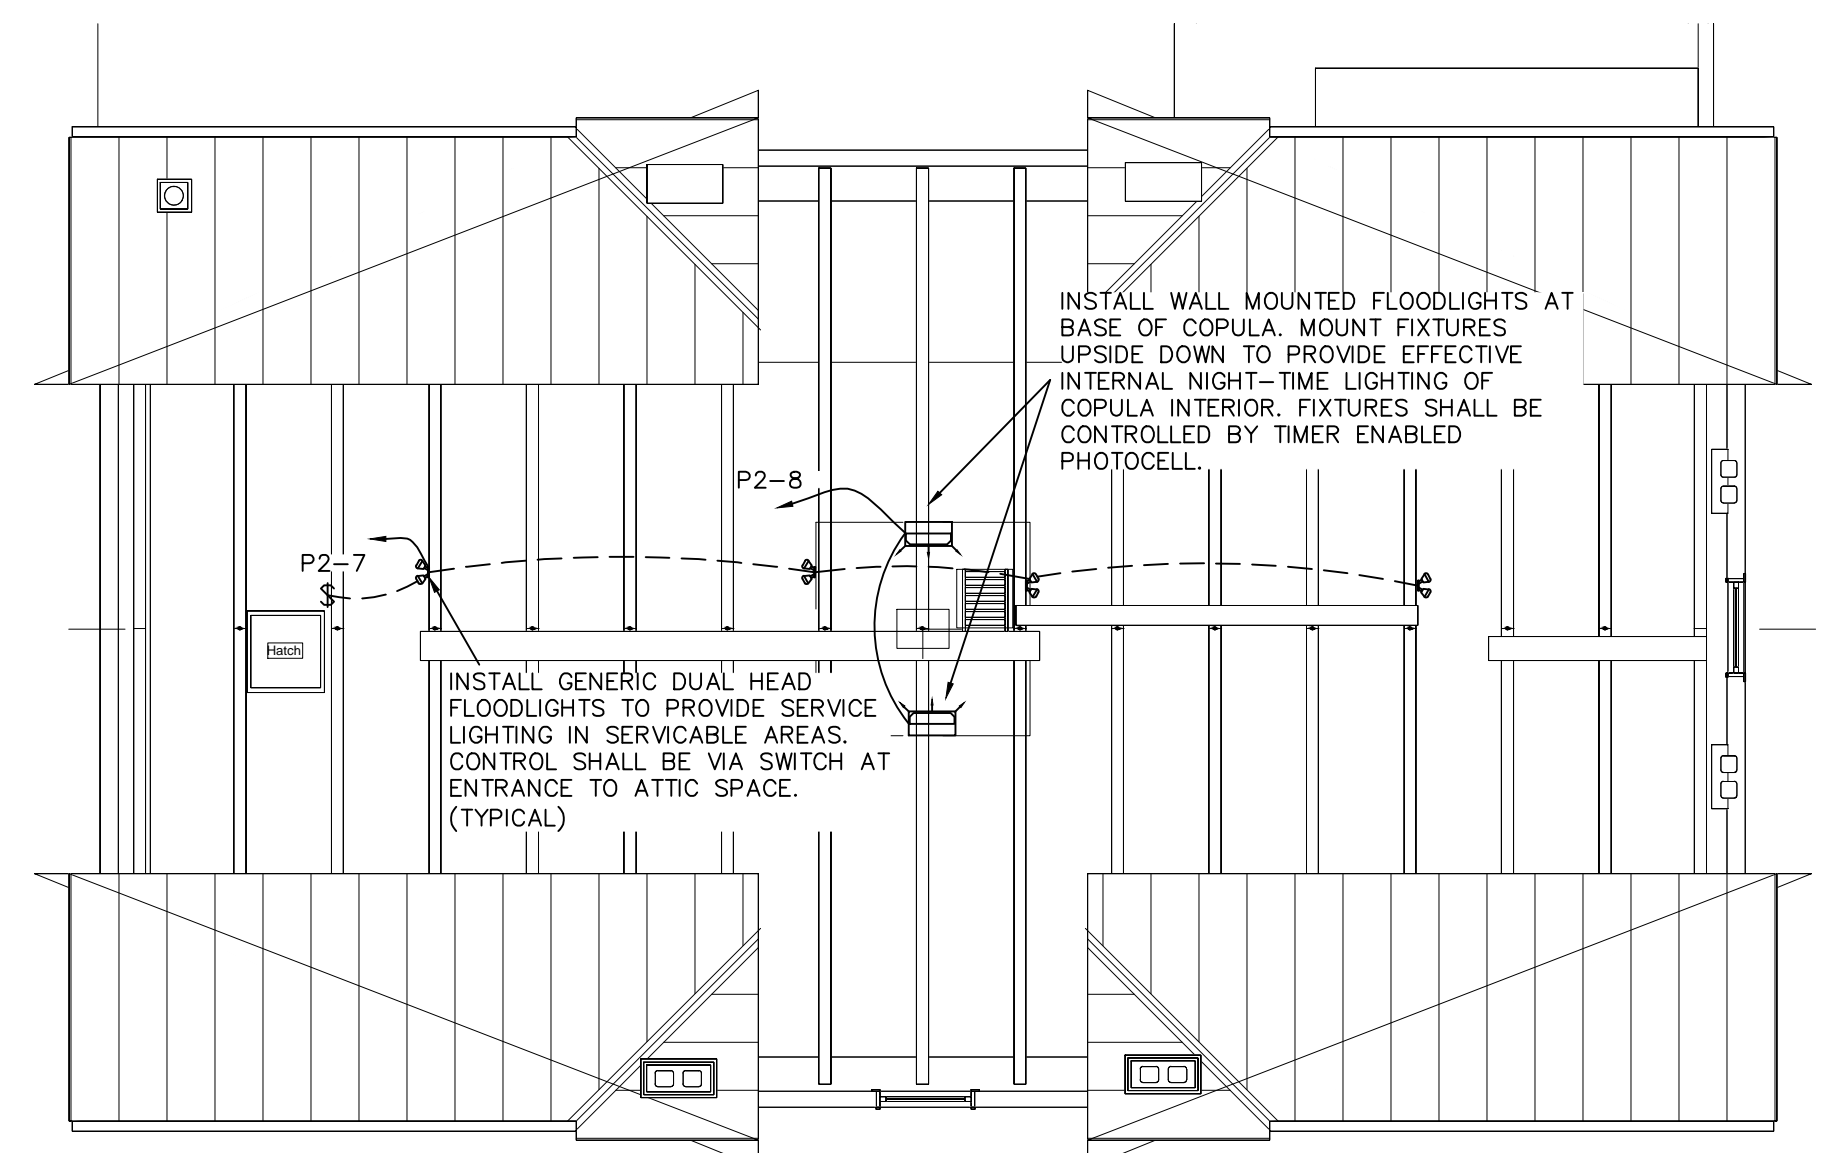

ATTIC LEVEL LIGHTING PLAN
3
E1-3 1/8" = 1'-0"

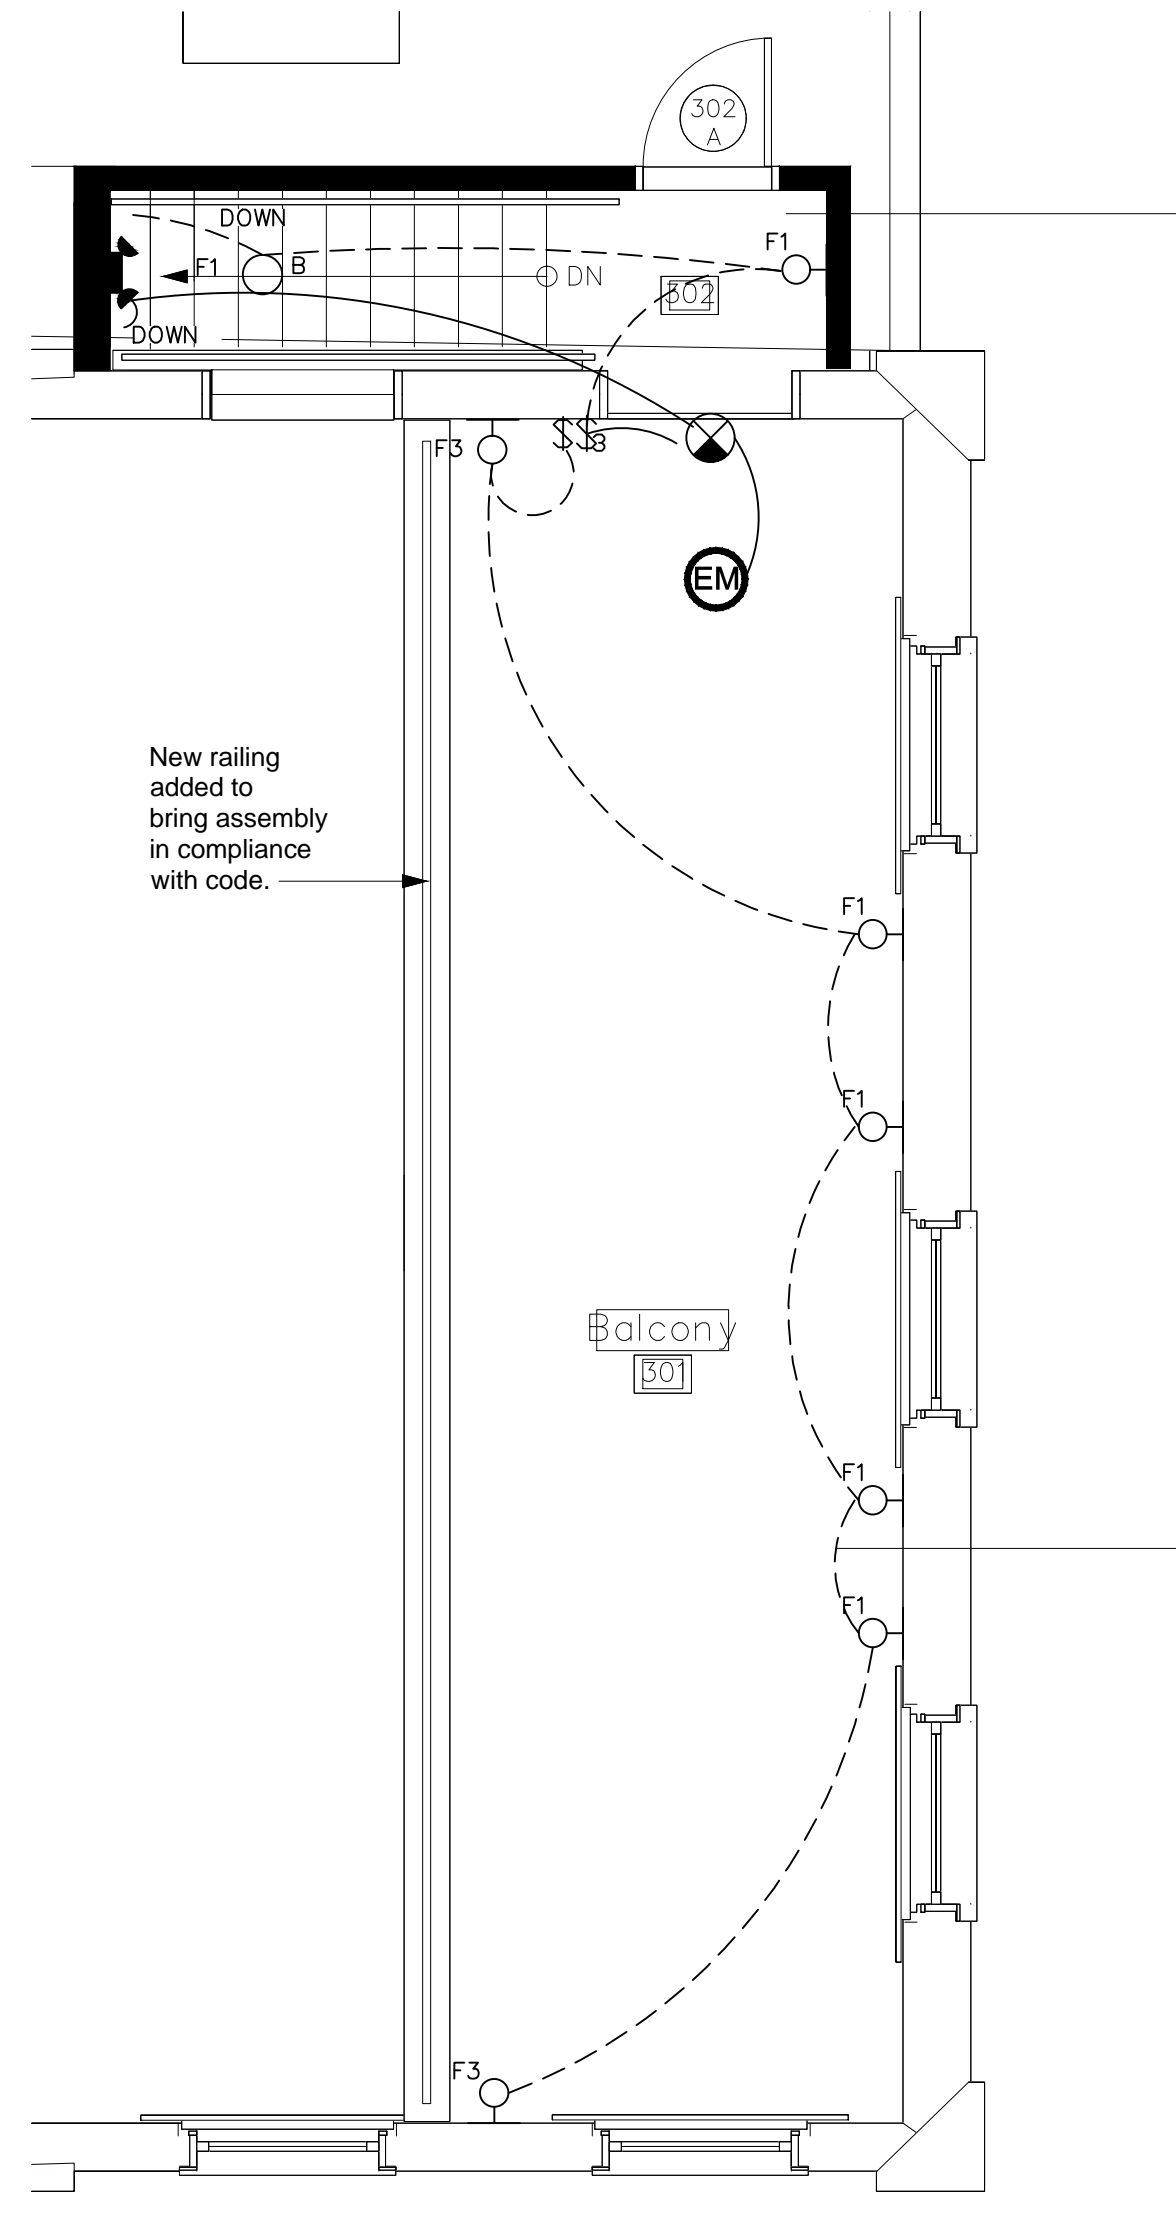

BALCONY UPPER LIGHTING PLAN
2
E1-3 1/4" = 1'-0"

Copyright 2014: COMFORT DESIGN INC. Michael F. Howell, P.E. 9/25/2014 9:58 AM E(CWH).dwg