


NORTH (magnetic)

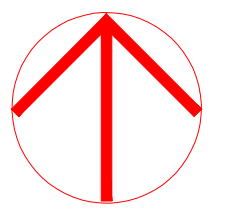

**Charles Washington Hall**  
RENOVATIONS  
Corner of George & Washington Streets  
Charles Town, W.Va.

For the  
**City of Charles Town**  
City of Ranson

Planning & Engineering (prime)  
**Hall Planning & Engineering, Inc**  
316 Williams Street  
Tallahassee, FL 32303

Landscape Architecture  
**Stromberg/Garrigan & Assoc., Inc.**  
102 E. Main Street-The Penn Bldg  
Somerset, PA 15501

Historic Preservation & Architecture  
**Landmarks SGA, LLC**  
102 E. Main Street-The Penn Bldg  
Somerset, PA 15501

Structural Engineer  
**R.L. Silman Associates**  
1053 31st Street NW  
Washington D.C. 20007

Mech/Elect Engineer  
**Comfort Design, Inc.**  
620 Pennsylvania Avenue  
Winchester, VA 22601

Architect




Issue/Revision Seal  
1 REVISED VRF MARCH 4, 2015

Drawing Title


**Basement Water & Gas Piping Plan**

Date 9/26/14  
Scale 1/4"=1'0" Project Number 11105  
Drawing Number




**P3.1**

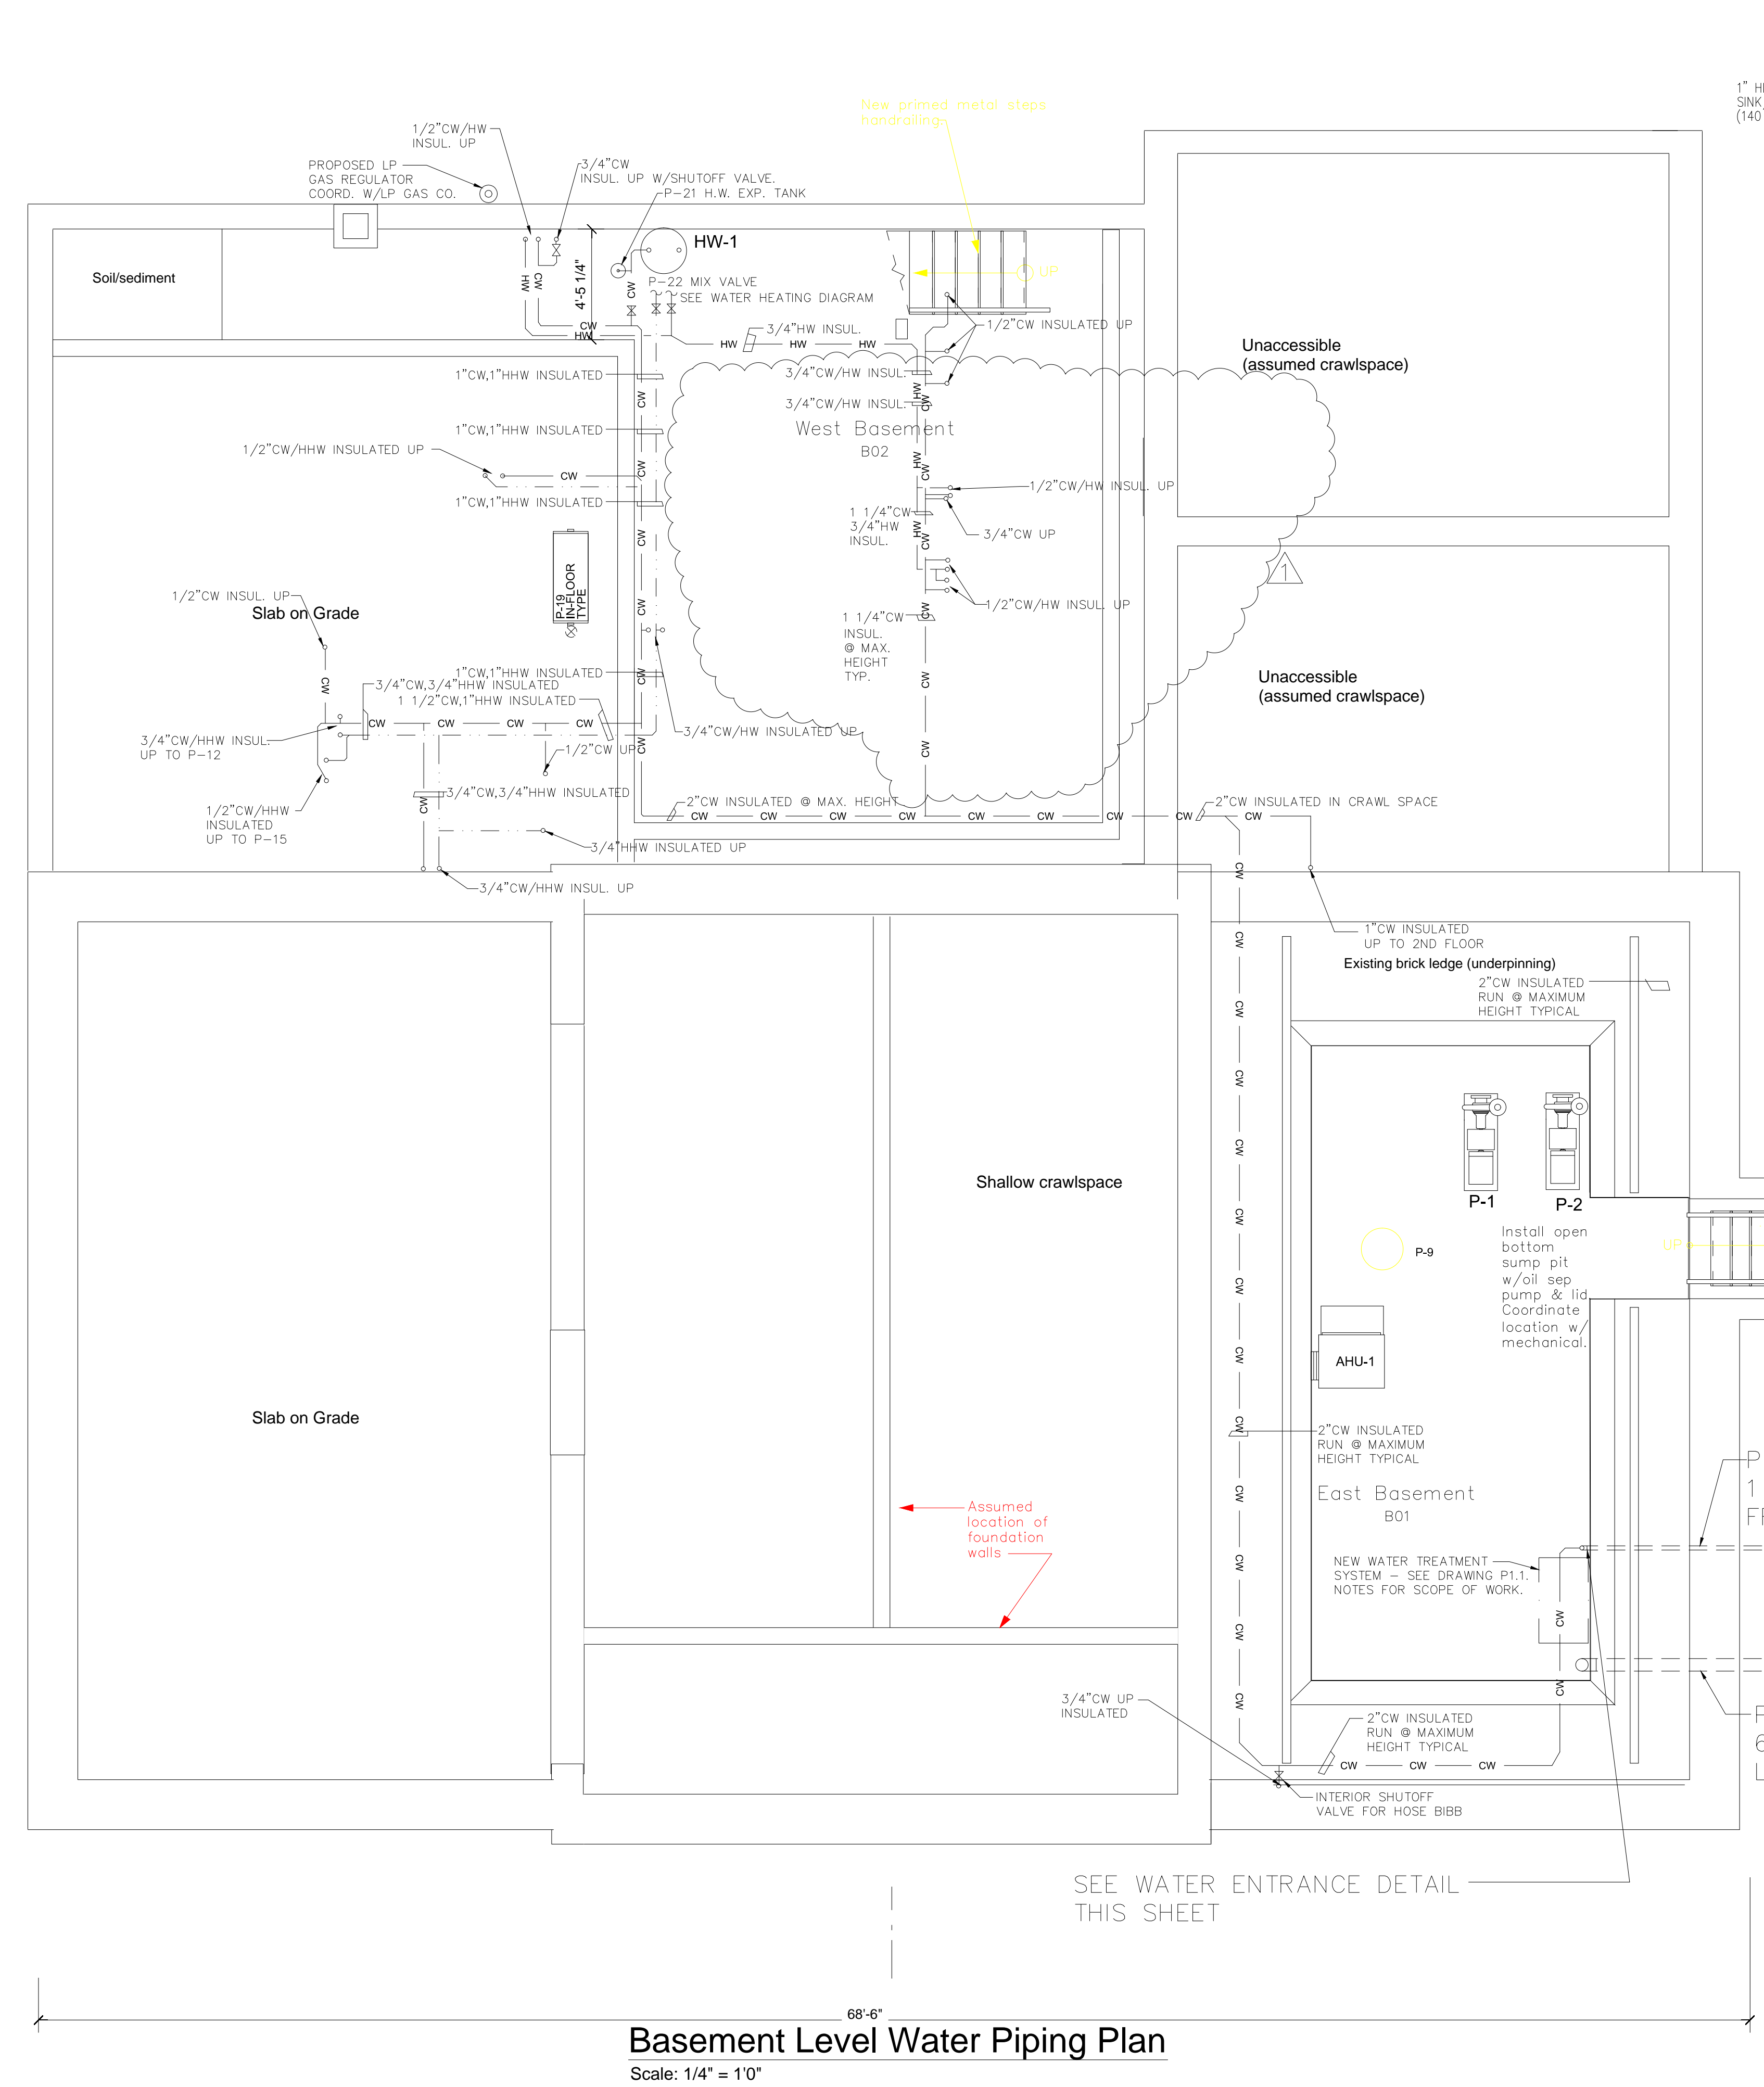

**Basement Level Water Piping Plan**  
Scale: 1/4" = 1'0"

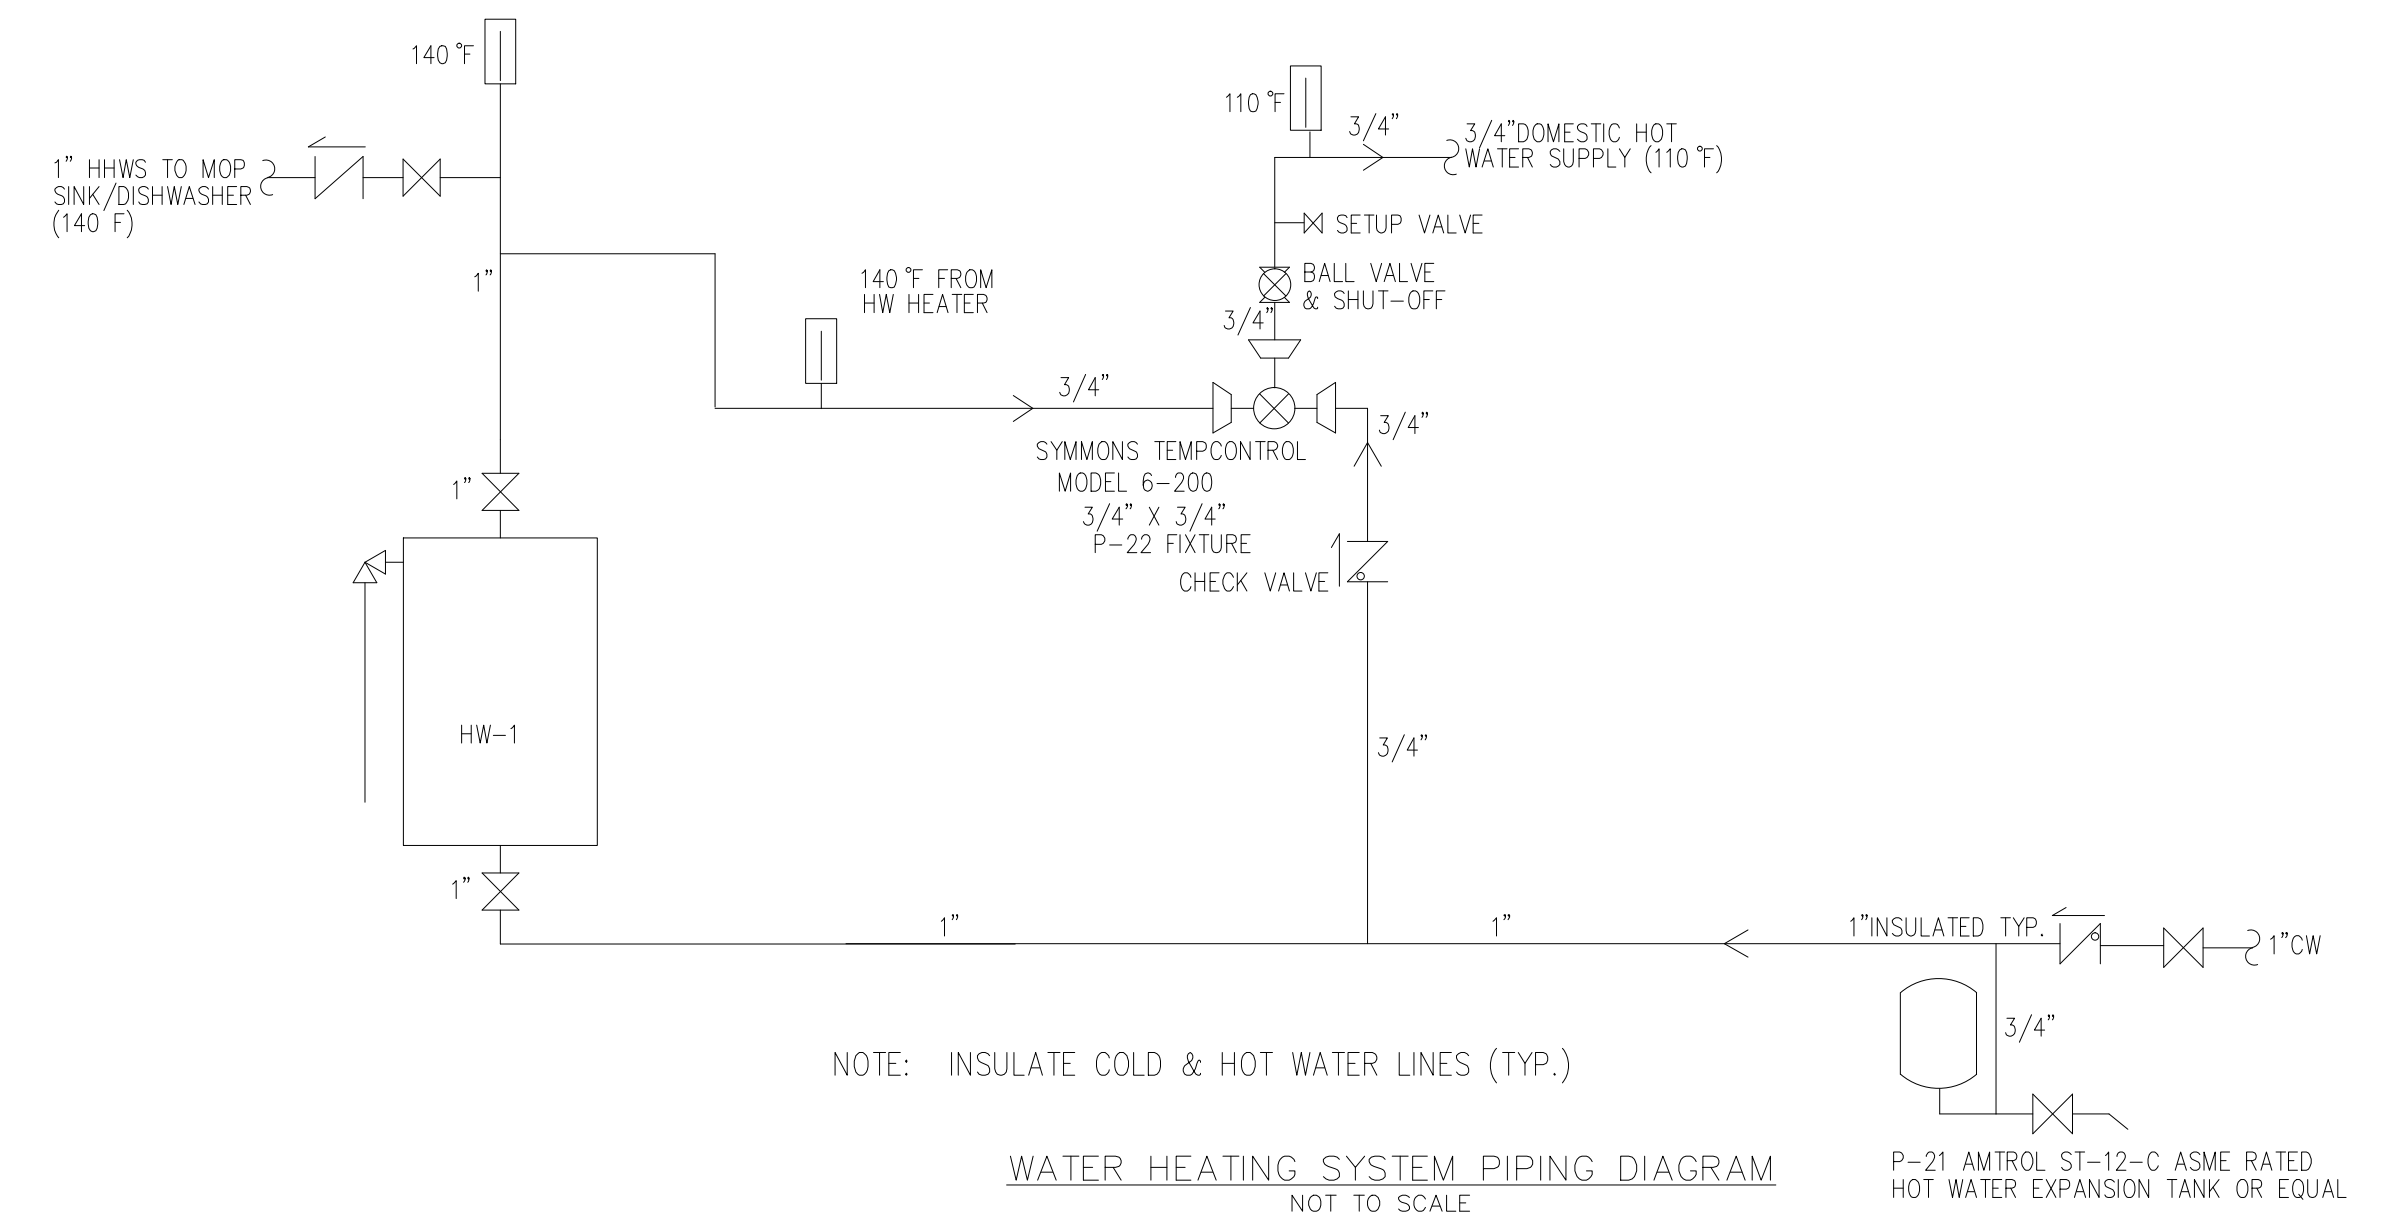

**WATER HEATING SYSTEM PIPING DIAGRAM**  
NOT TO SCALE

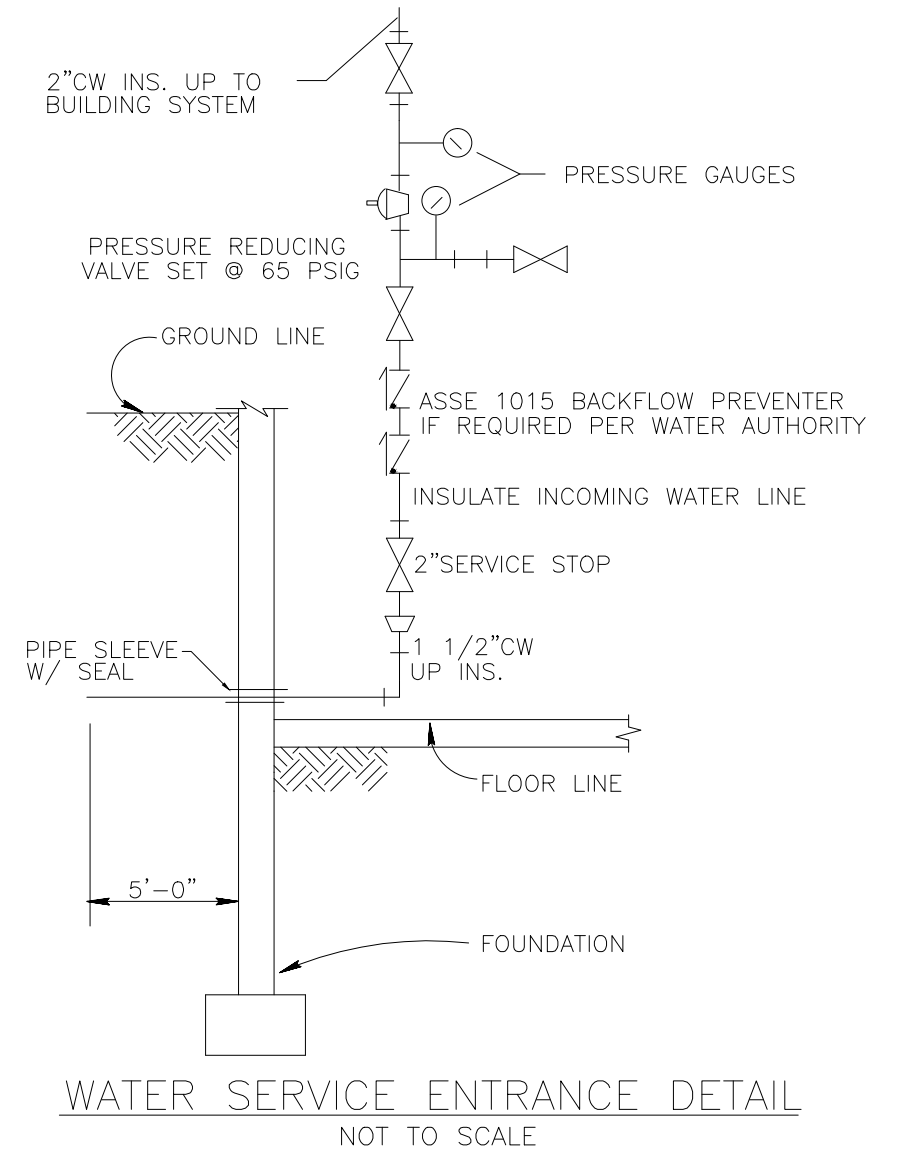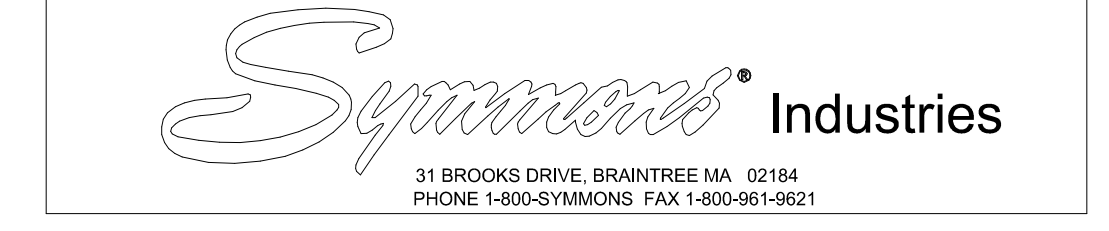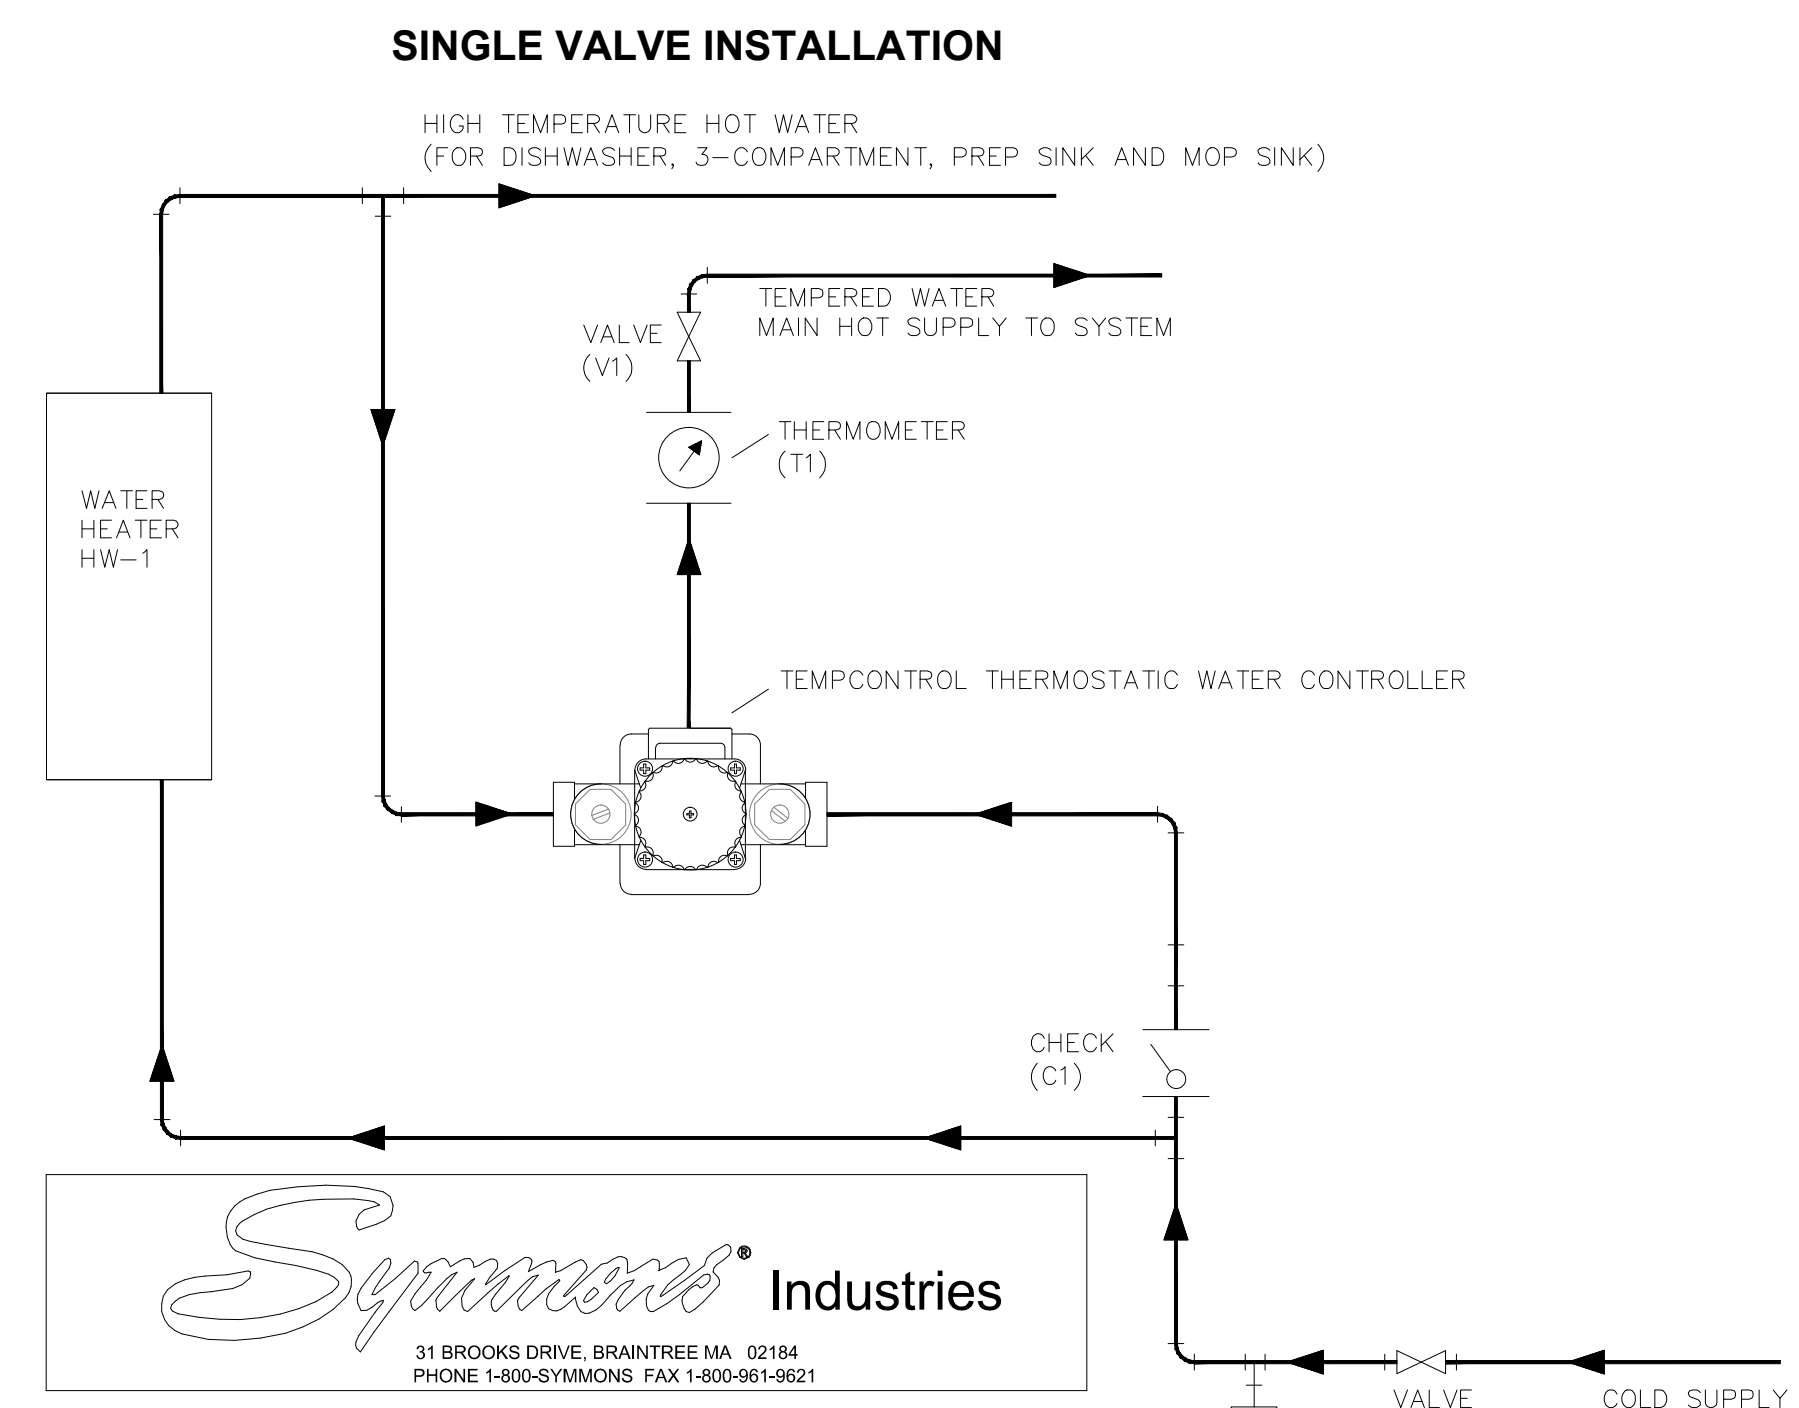

**WATER SERVICE ENTRANCE DETAIL**  
NOT TO SCALE