


SHEET KEYED NOTES

1 ROUTE 3/4" CONDUIT FROM FLOOR BOXES TO WALL BOXES WITH PULL CORD.
 WALL BOXES TO BE SINGLE GANG WITH BLANK COVERS.

Revisions:

No:	Date:
No:	Date:
No:	Date:
No:	Date:
No:	Date:

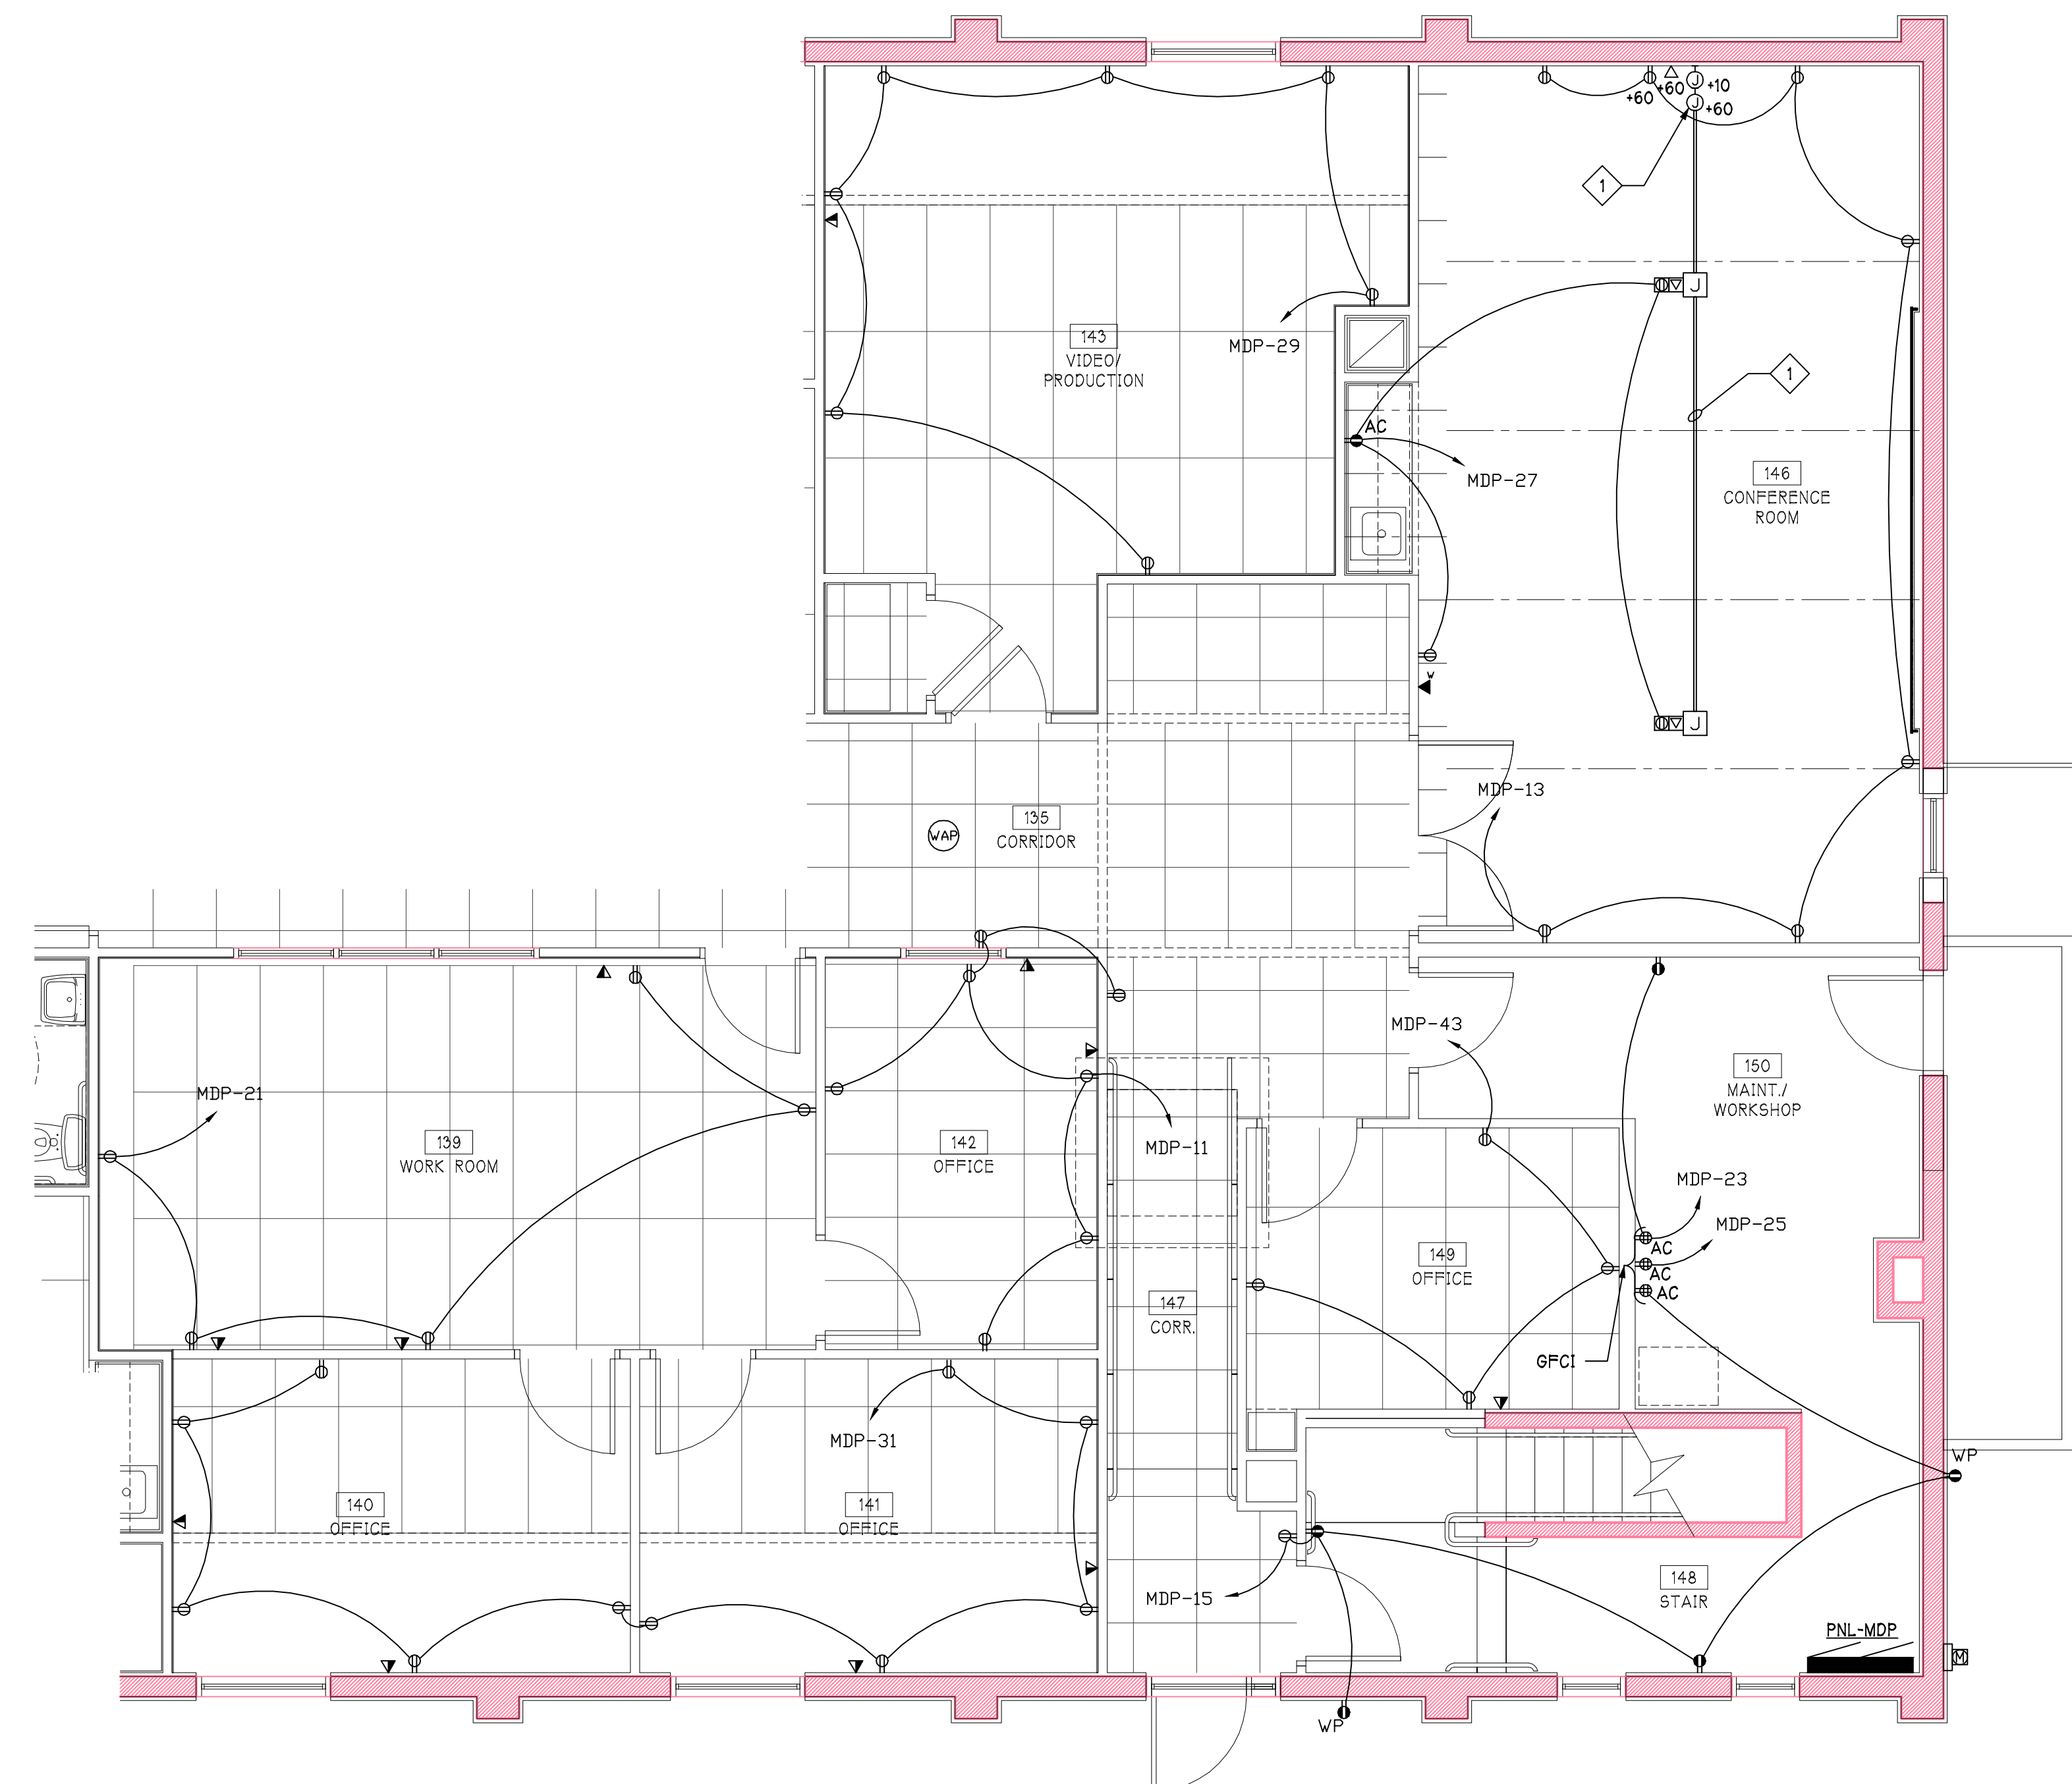

ENLARGED POWER PLAN
 1
 E401
 1/4" = 1'-0"

NEWCOMER ASSOCIATES
 architecture + engineering
 1105 Shiller Avenue - Chambersburg, PA 17201 Tel: 717.265.0100 Fax: 717.263.7380 www.newcomerassociates.com

**King Street Church
 Office Building Renovation**
 56 North Second Street Chambersburg, Pennsylvania 17201

© 2015 Newcomer Associates, Inc.

Drawing Title:
 ENLARGED
 POWER PLAN

Sheet No.
E401
Date: January 29, 2016