



Revisions:	
No:	Date:
No:	Date:
No:	Date:
No:	Date:
No:	Date:

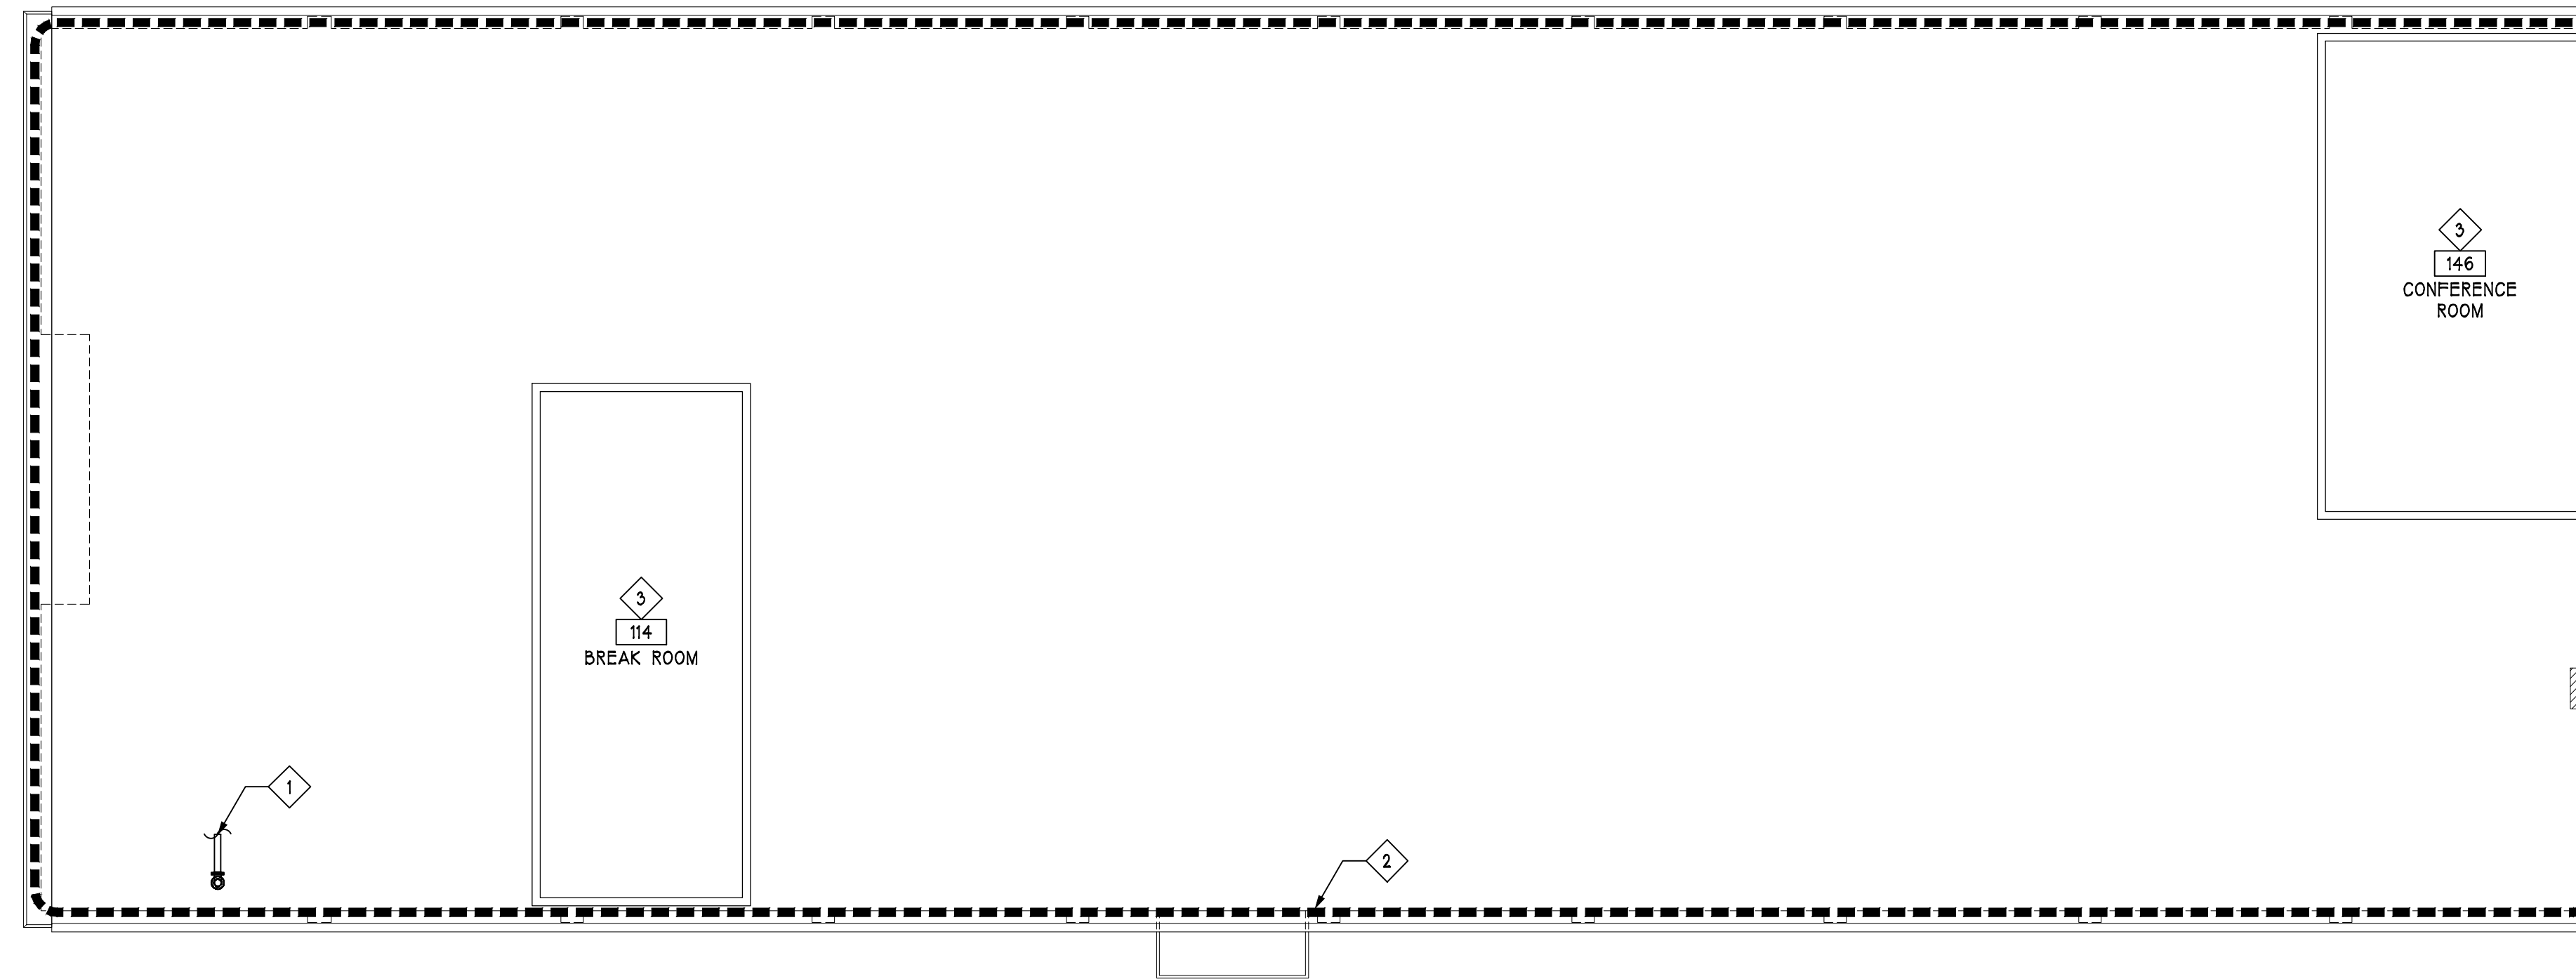

BELOW ROOF FIRE PROTECTION PLAN

1/8" = 1'-0"


BELOW ROOF KEYED NOTES	
1	ROUTE 4" FIRE PROTECTION RISER UP INTO ATTIC SPACE FROM FLOOR BELOW. COORDINATE FIRE PROTECTION PIPE ROUTING AND ATTIC SPACE SPRINKLER HEAD LOCATIONS WITH EXISTING CONDITIONS AND MECHANICAL TRADES.
2	PROVIDE AN AUTOMATIC WET PIPE SPRINKLER SYSTEM IN ACCORDANCE WITH NFPA 13 LIGHT HAZARD CLASSIFICATION. HYDRAULIC CALCULATIONS SHALL BE BASED ON DENSITY OF 0.1 GPM/SQ. FT. OVER THE MOST REMOTE 1500 SQ. FT.
3	DO NOT ROUTE ANY FIRE PROTECTION PIPING THROUGH INDICATED ROOM. CEILING IS OPEN UP TO EXPOSED ROOF DECK. COORDINATE WITH ARCHITECTURAL TRADES.

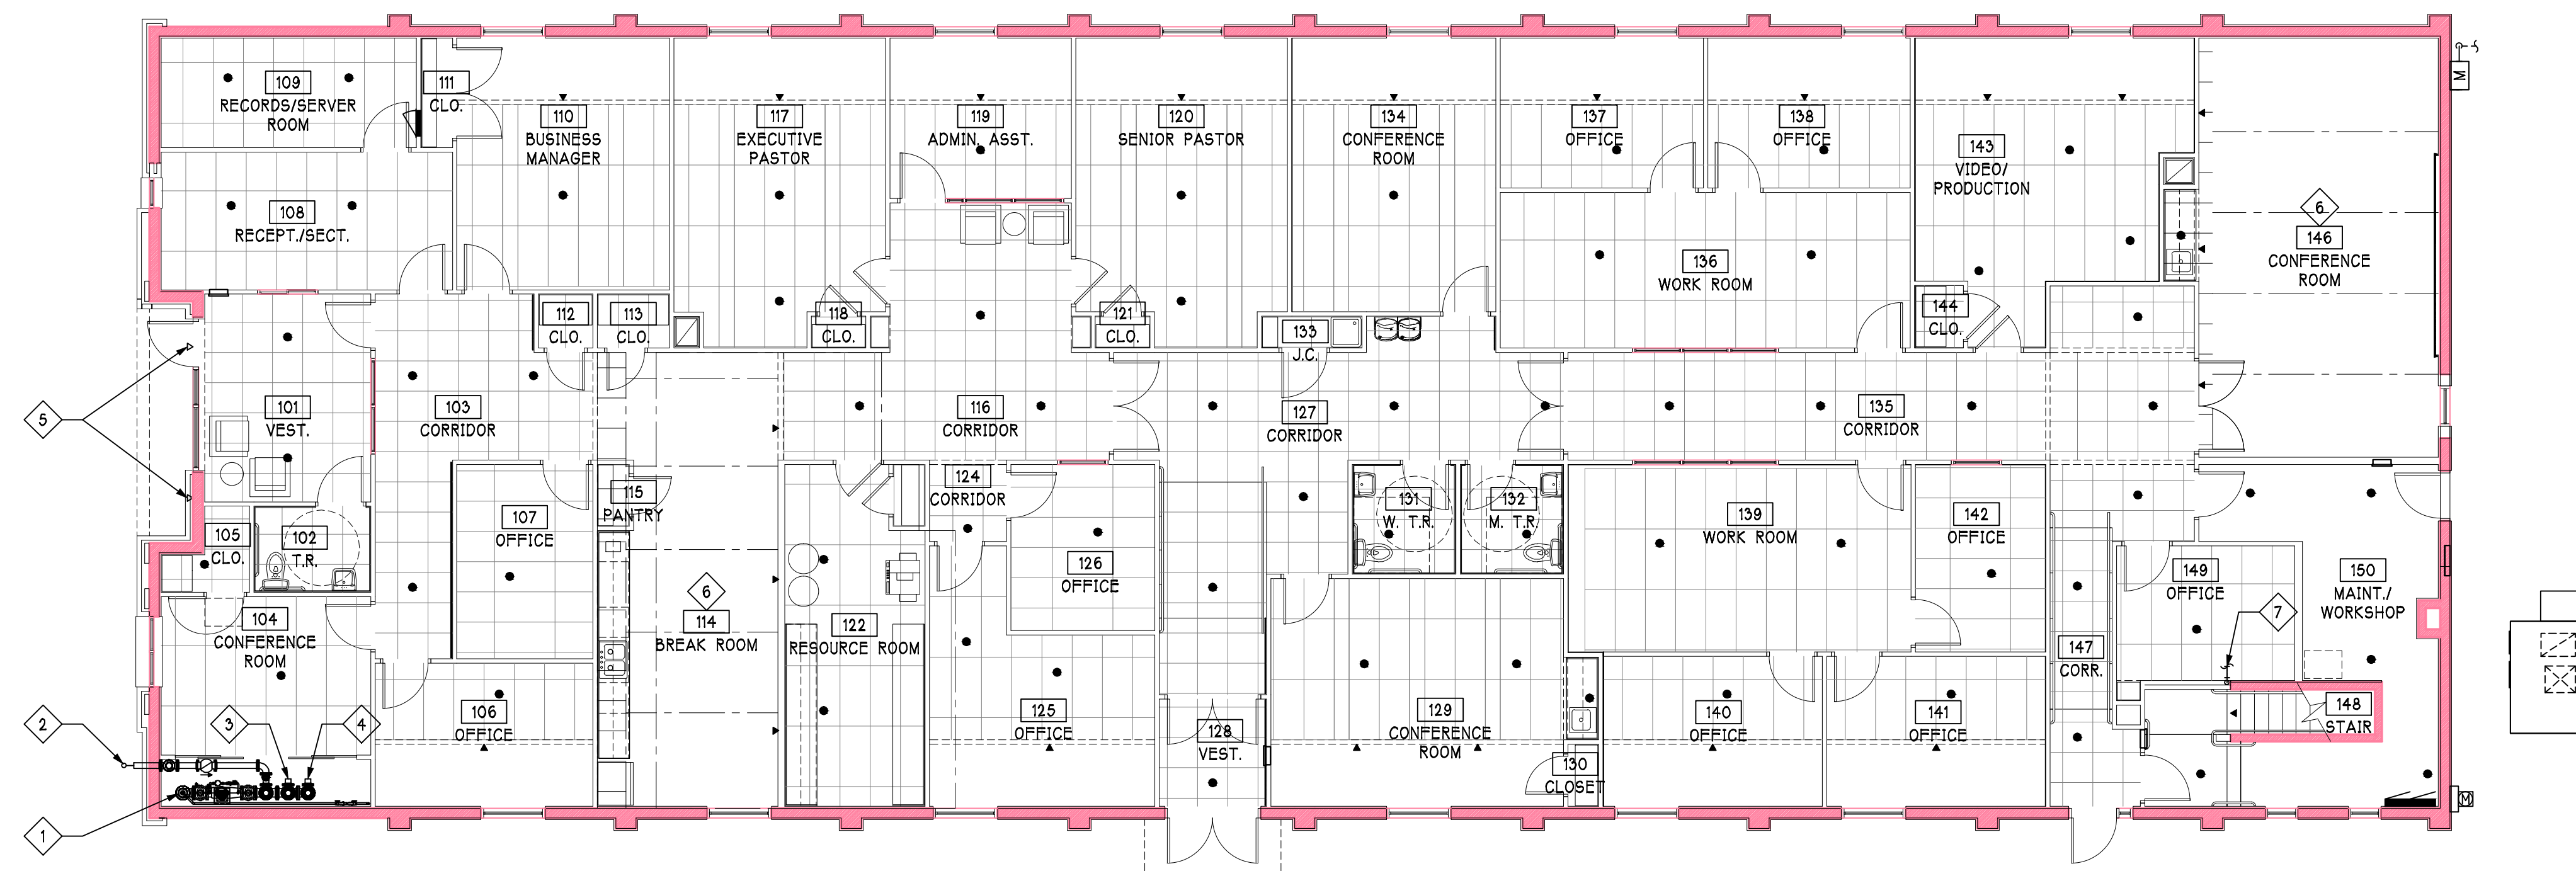

FIRST FLOOR FIRE PROTECTION PLAN

1/8" = 1'-0"

FIRST FLOOR KEYED NOTES	
1	6" COMBINATION FIRE PROTECTION AND DOMESTIC SUPPLY BUILDING ENTRY.
2	5" STORTZ FIRE DEPARTMENT CONNECTION. COORDINATE REQUIREMENTS WITH LOCAL AUTHORITY HAVING JURISDICTION.
3	OFFICE AND CEILING SPACE FIRE PROTECTION RISER.
4	ATTIC SPACE FIRE PROTECTION RISER.
5	"FREEZER" TYPE SIDEWALL NON-FREEZE SPRINKLER HEAD.
6	DO NOT ROUTE ANY FIRE PROTECTION PIPING THROUGH INDICATED ROOM. CEILING IS OPEN UP TO EXPOSED ROOF DECK. COORDINATE WITH ARCHITECTURAL TRADES.
7	ROUTE FIRE PROTECTION BRANCH DOWN IN WALL FOR BASEMENT COVERAGE.

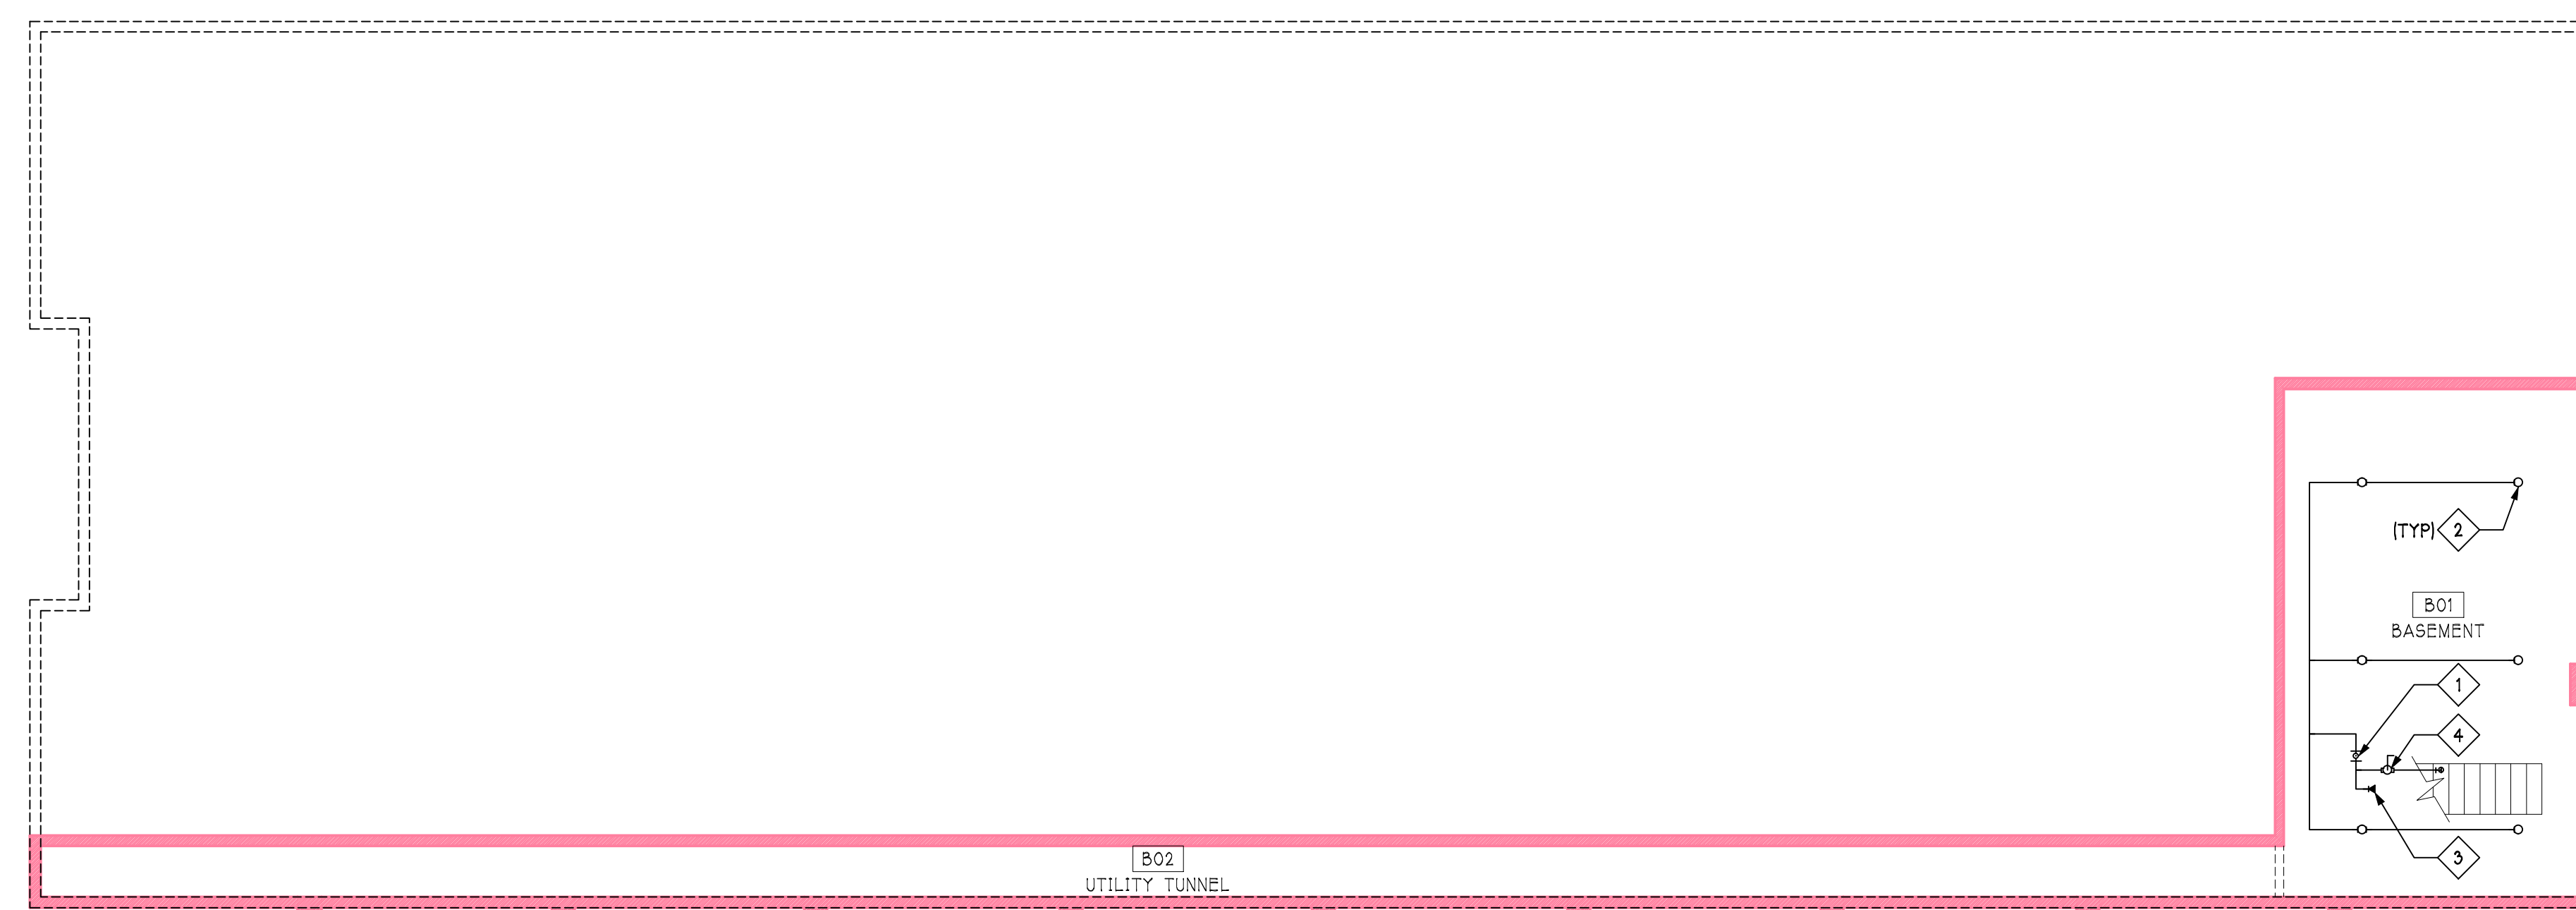

BASEMENT FIRE PROTECTION PLAN

1/8" = 1'-0"

BASEMENT KEYED NOTES	
1	ROUTE FIRE PROTECTION PIPE DOWN IN WALL OF FLOOR ABOVE.
2	COORDINATE FIRE PROTECTION PIPE ROUTING AND SPRINKLER HEAD LOCATIONS WITH ALL TRADES AND EXISTING CONDITIONS.
3	DIRECT SIDE WALL SPRINKLER HEAD TOWARDS UNDERSIDE OF STAIRS.
4	BASEMENT FIRE PROTECTION SYSTEM DRAIN DOWN VALVE. DISCHARGE DRAIN DOWN INTO SUMP. COORDINATE WITH PLUMBING TRADES.

NEWCOMER ASSOCIATES
 architecture + engineering
1105 Shiller Avenue - Chambersburg, PA 17201 Tel: 717.265.0101 Fax: 717.263.7580 www.newcomerassociates.com

**King Street Church
 Office Building Renovation**
56 North Second Street Chambersburg, Pennsylvania 17201

© 2016
 Newcomer Associates, Inc.

Drawing Title:
 FIRE PROTECTION PLANS

Sheet No.

FP101

Date: January 29, 2016

